

PROJECT TYPE

DRAWINGS/SPECIFICATIONS BY:
 WALGREENS' CONSULTANT
 LANDLORD'S CONSULTANT
ALL CONSTRUCTION WORK UNLESS NOTED OTHERWISE BY:
 WALGREENS' CONTRACTOR
 LANDLORD'S CONTRACTOR (TURNKEY CONSTRUCTION)

STORE

NEW.....
REMODELING.....
RELOCATION.....
OTHERS.....

BUILDING

NEW.....
EXISTING.....
NEW SHELL ONLY.....

REVISIONS

| NO. | DATE | BY | DESCRIPTION | CONST. |
|-----|----------|------|----------------|---------|
| 1 | 11/12/93 | P.F. | NEW BALER ROOM | 7/13/93 |
| | | | | |
| | | | | |
CERTIFICATION AND SEAL


I HEREBY CERTIFY THAT THIS PLAN AND SPECIFICATION WAS PREPARED BY ME OR UNDER MY DIRECT SUPERVISION AND THAT I AM A DULY REGISTERED ARCHITECT OR ENGINEER UNDER THE LAWS OF THE STATE OF COLORADO AS SIGNIFIED BY MY HAND AND SEAL.

PROJECT NAME
2000 E. COLFAX
DENVER, COLORADO


DRAWING TITLE
MECHANICAL PLAN

DATE 6-28-93 STORE NO. 01769 DRAWING NO.
 DRAWN BY: P.F. SCALE 1/8"=1'-0" M.I.I.
 REVIEWED BY: HRV/ GNP RELEASED TO CONSTRUCTION 7/13/93 OF DMCS.

PROVIDE 4" VENT PIPE THRU ROOF WITH VENT TERMINAL CAP.
 GAS FIRED UNIT HEATER - REZNOR SEE EXL-3 1/2" H.P. 120V 10 MOTOR 30000 BTU INPUT - 24,900 BTU OUTPUT 66 POUNDS. THERMOST. MTD. ON WALL 6'6" UP. SUPPORT UNIT HEATER FROM WALL & RAFTERS

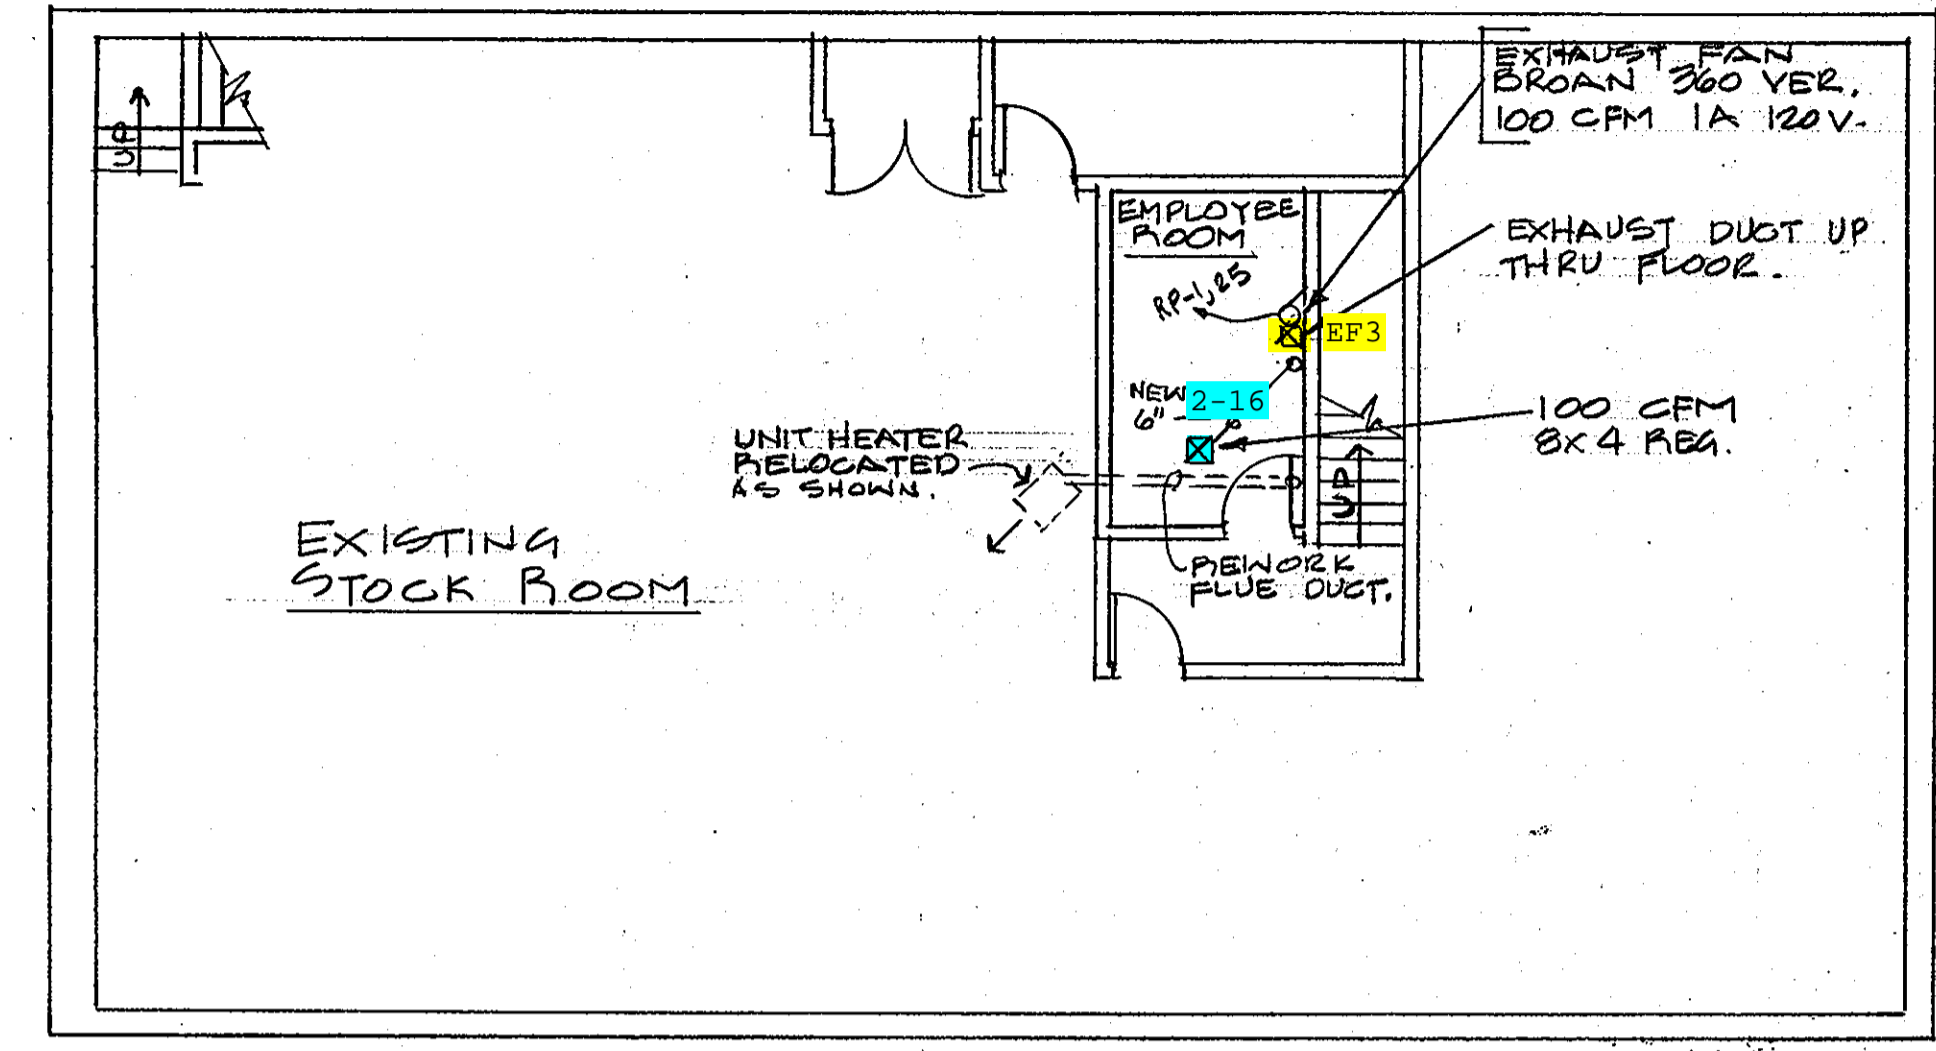

BASEMENT

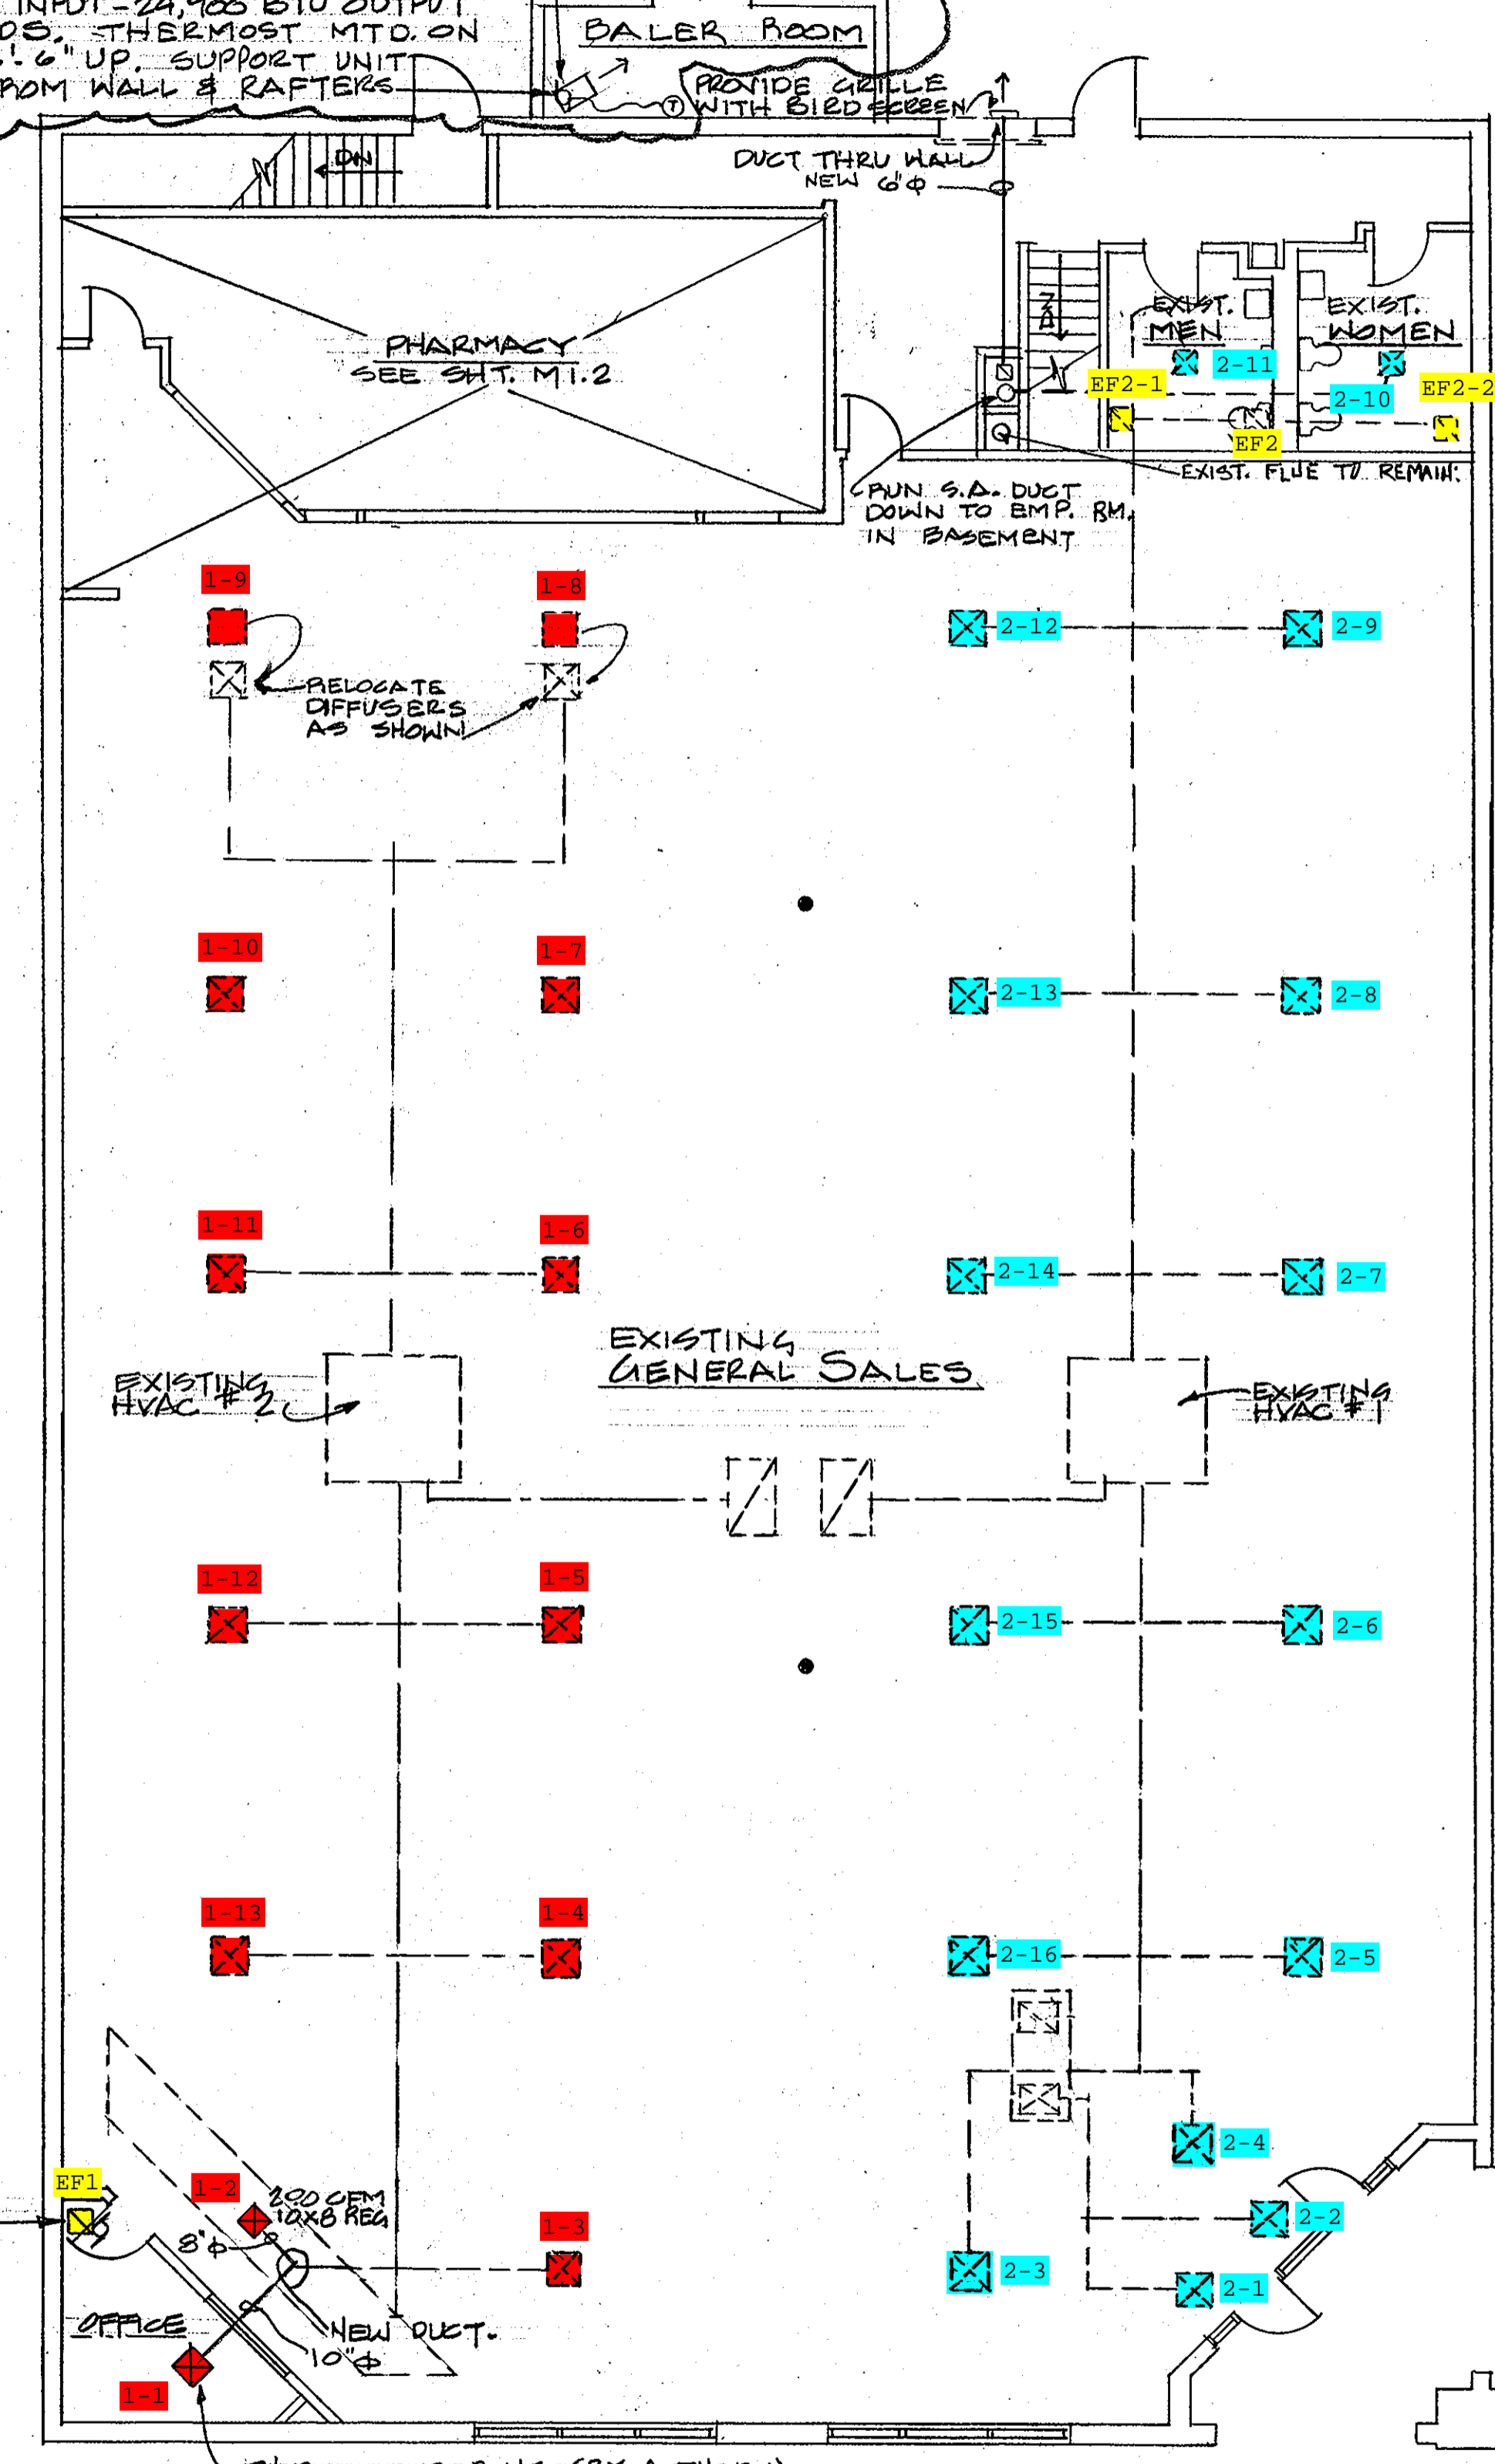

FLOOR PLAN

EXHAUST AIR TO SPACE ABOVE CEILING - 200 CFM, ON THERMOSTAT. BROAN # 365, 3A 120V.

THERMO-FUSER HC (BY ACTHERN) 200 CFM.

