


**MECHANICAL PLAN**  
SCALE: 1/4" = 1'-0"

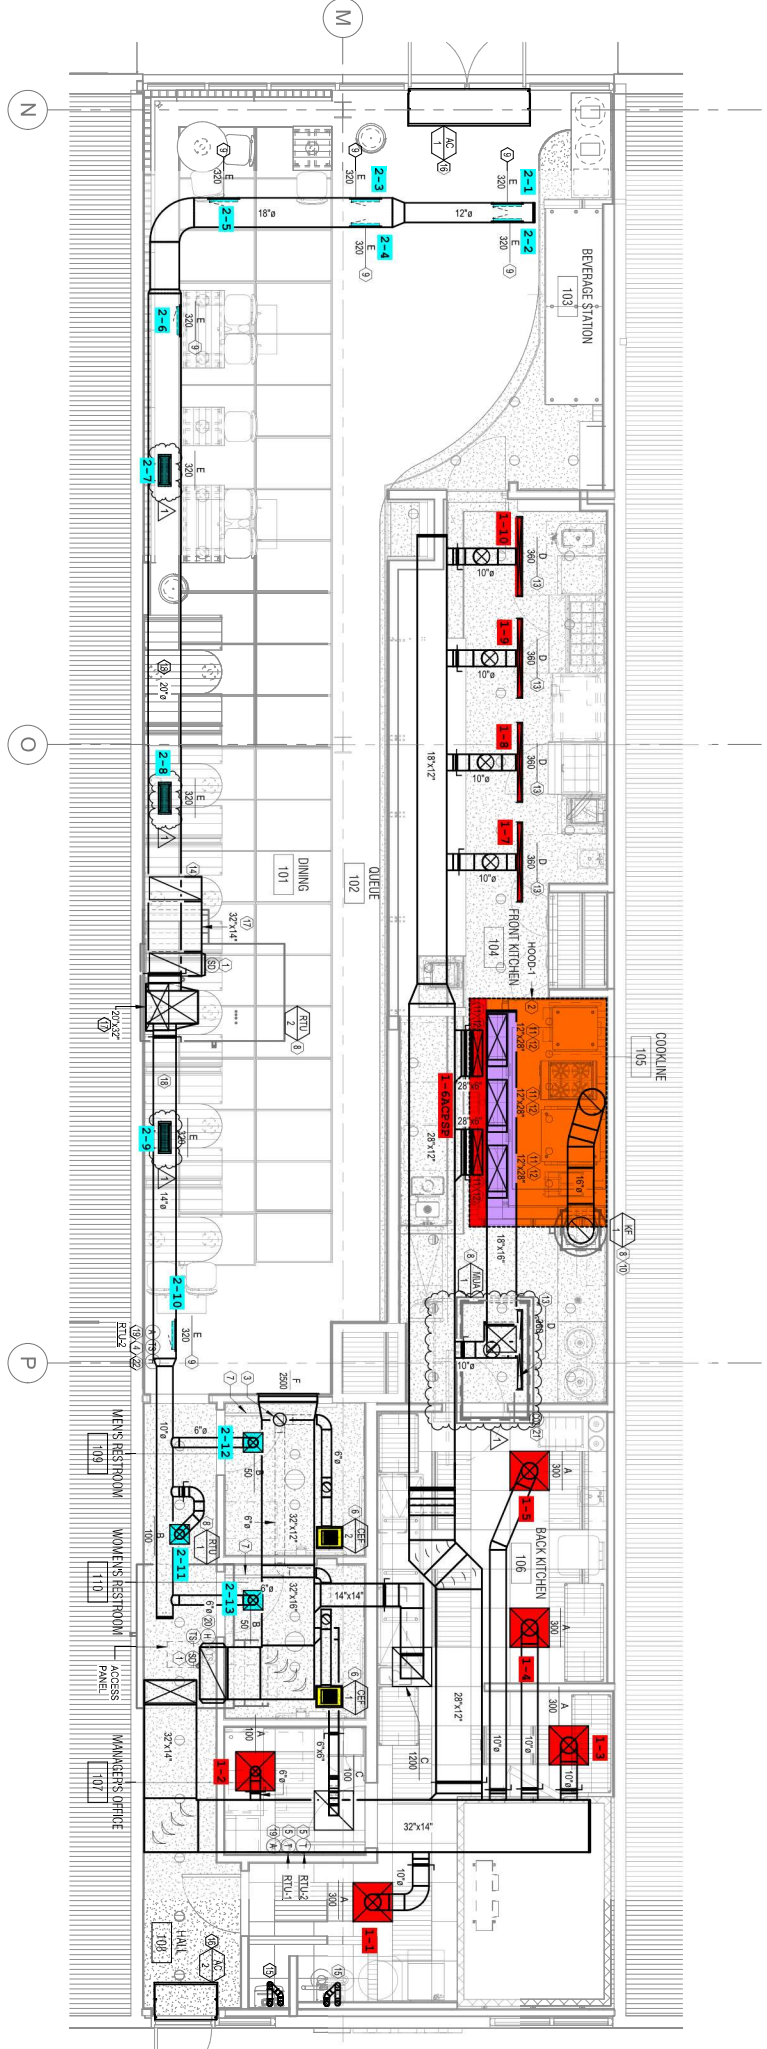

N

N

O

P

M

MEN'S RESTROOM 109

WOMEN'S RESTROOM 110

ACCESS PANEL

MANAGERS OFFICE 107

HALL 108

BEVERAGE STATION 103

COOKLINE 105

FRONT KITCHEN 104

BACK KITCHEN 106

QUEUE 102

DINING 101