


FOURTH FLOOR REVISED DUCTWORK PLAN - WEST

SCALE: 1/8" = 1'-0"



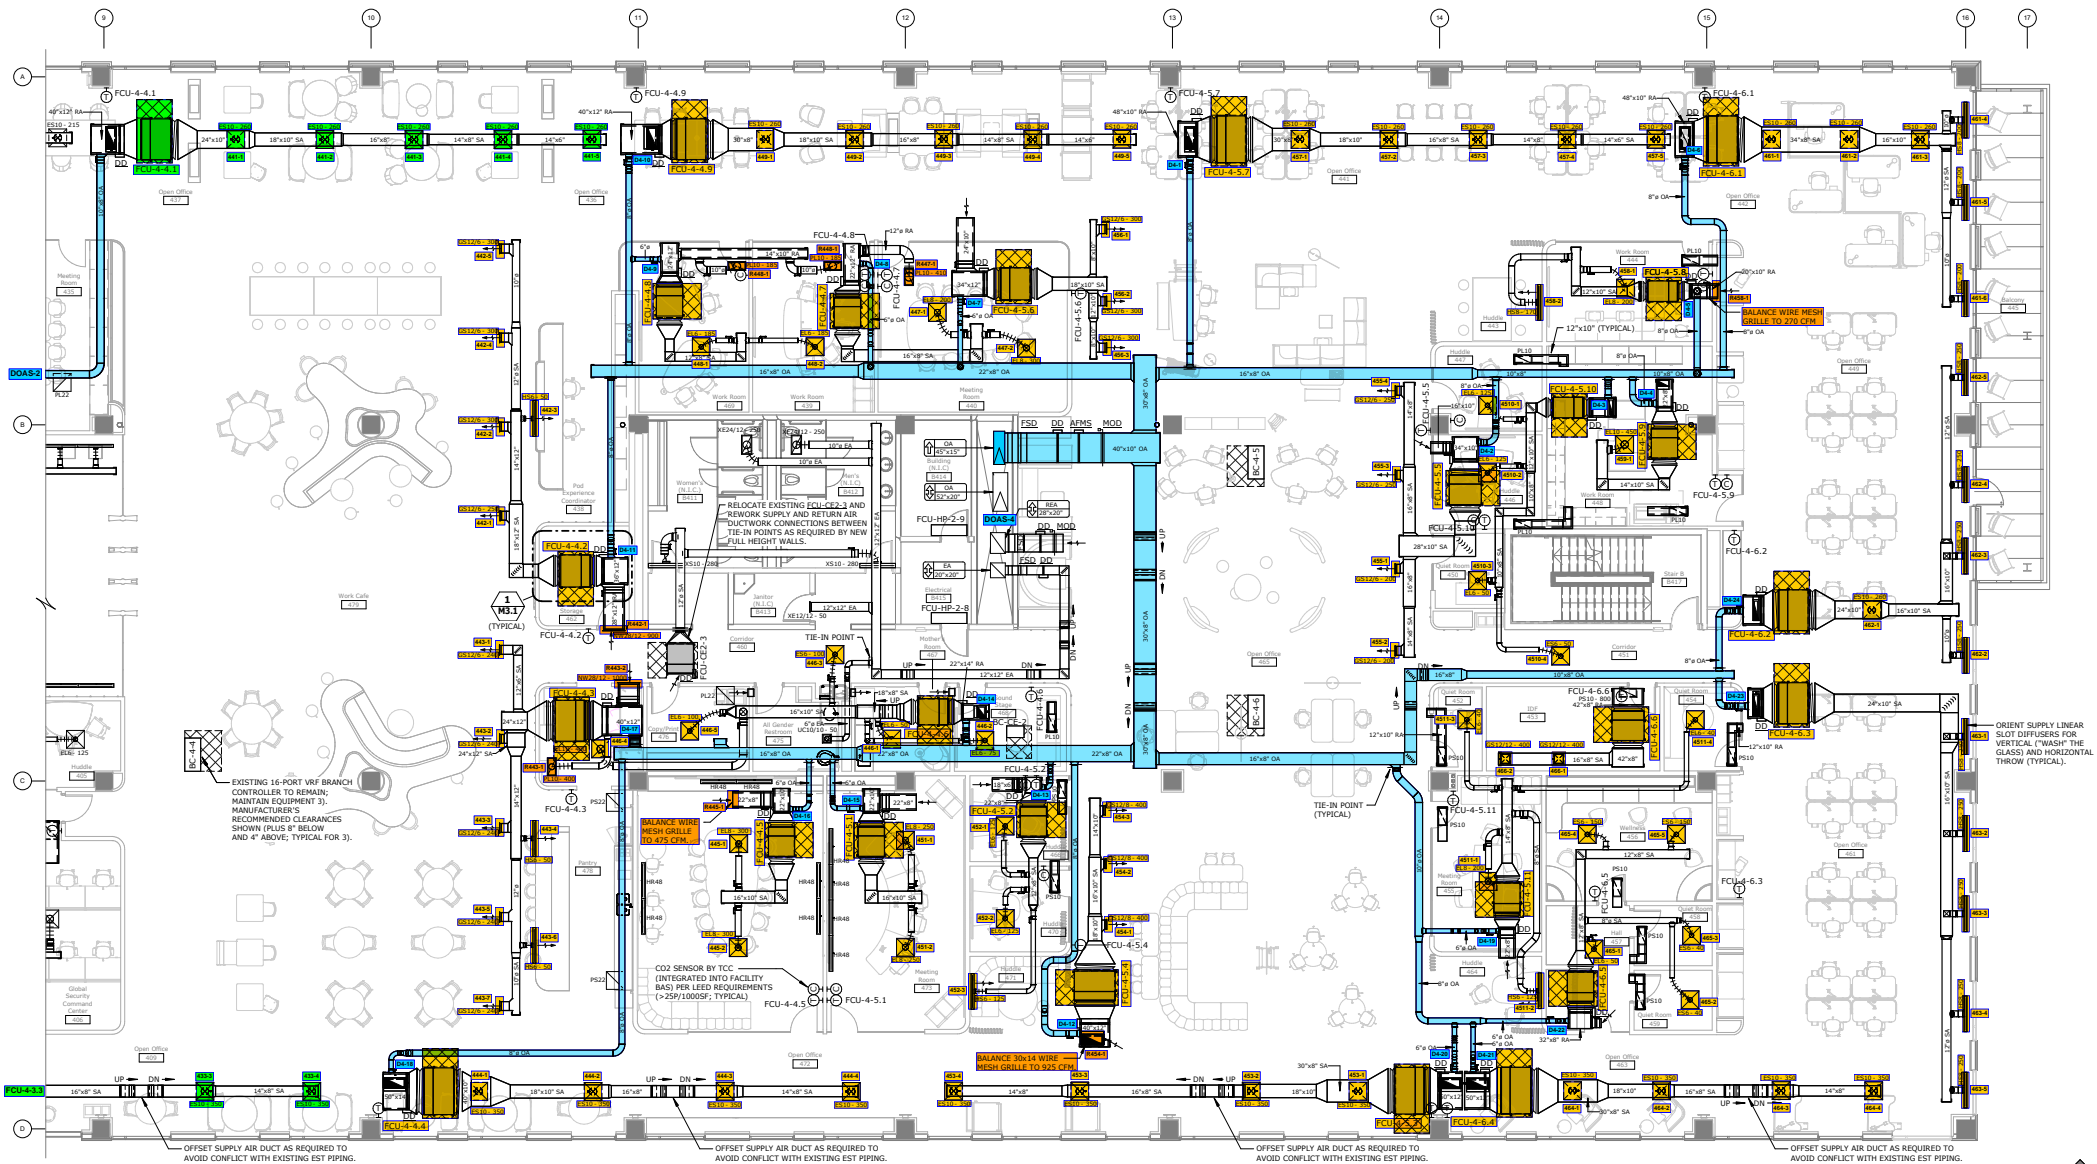

FOURTH FLOOR REVISED DUCTWORK PLAN - EAST

SCALE: 1/8" = 1'-0"

