




13 BURGLAR BAR DETAILS
SCALE: NONE

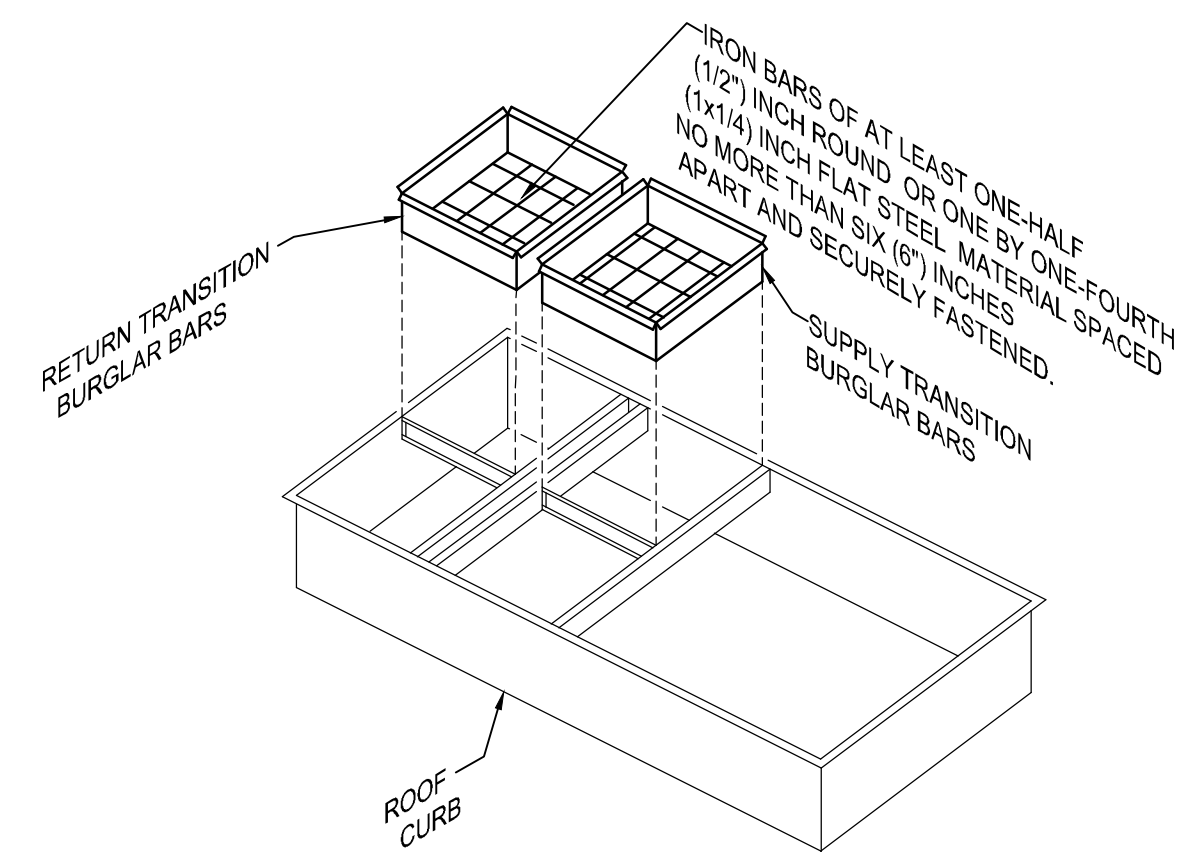


14 DUCT MOUNTED REGISTER DETAIL
SCALE: NONE

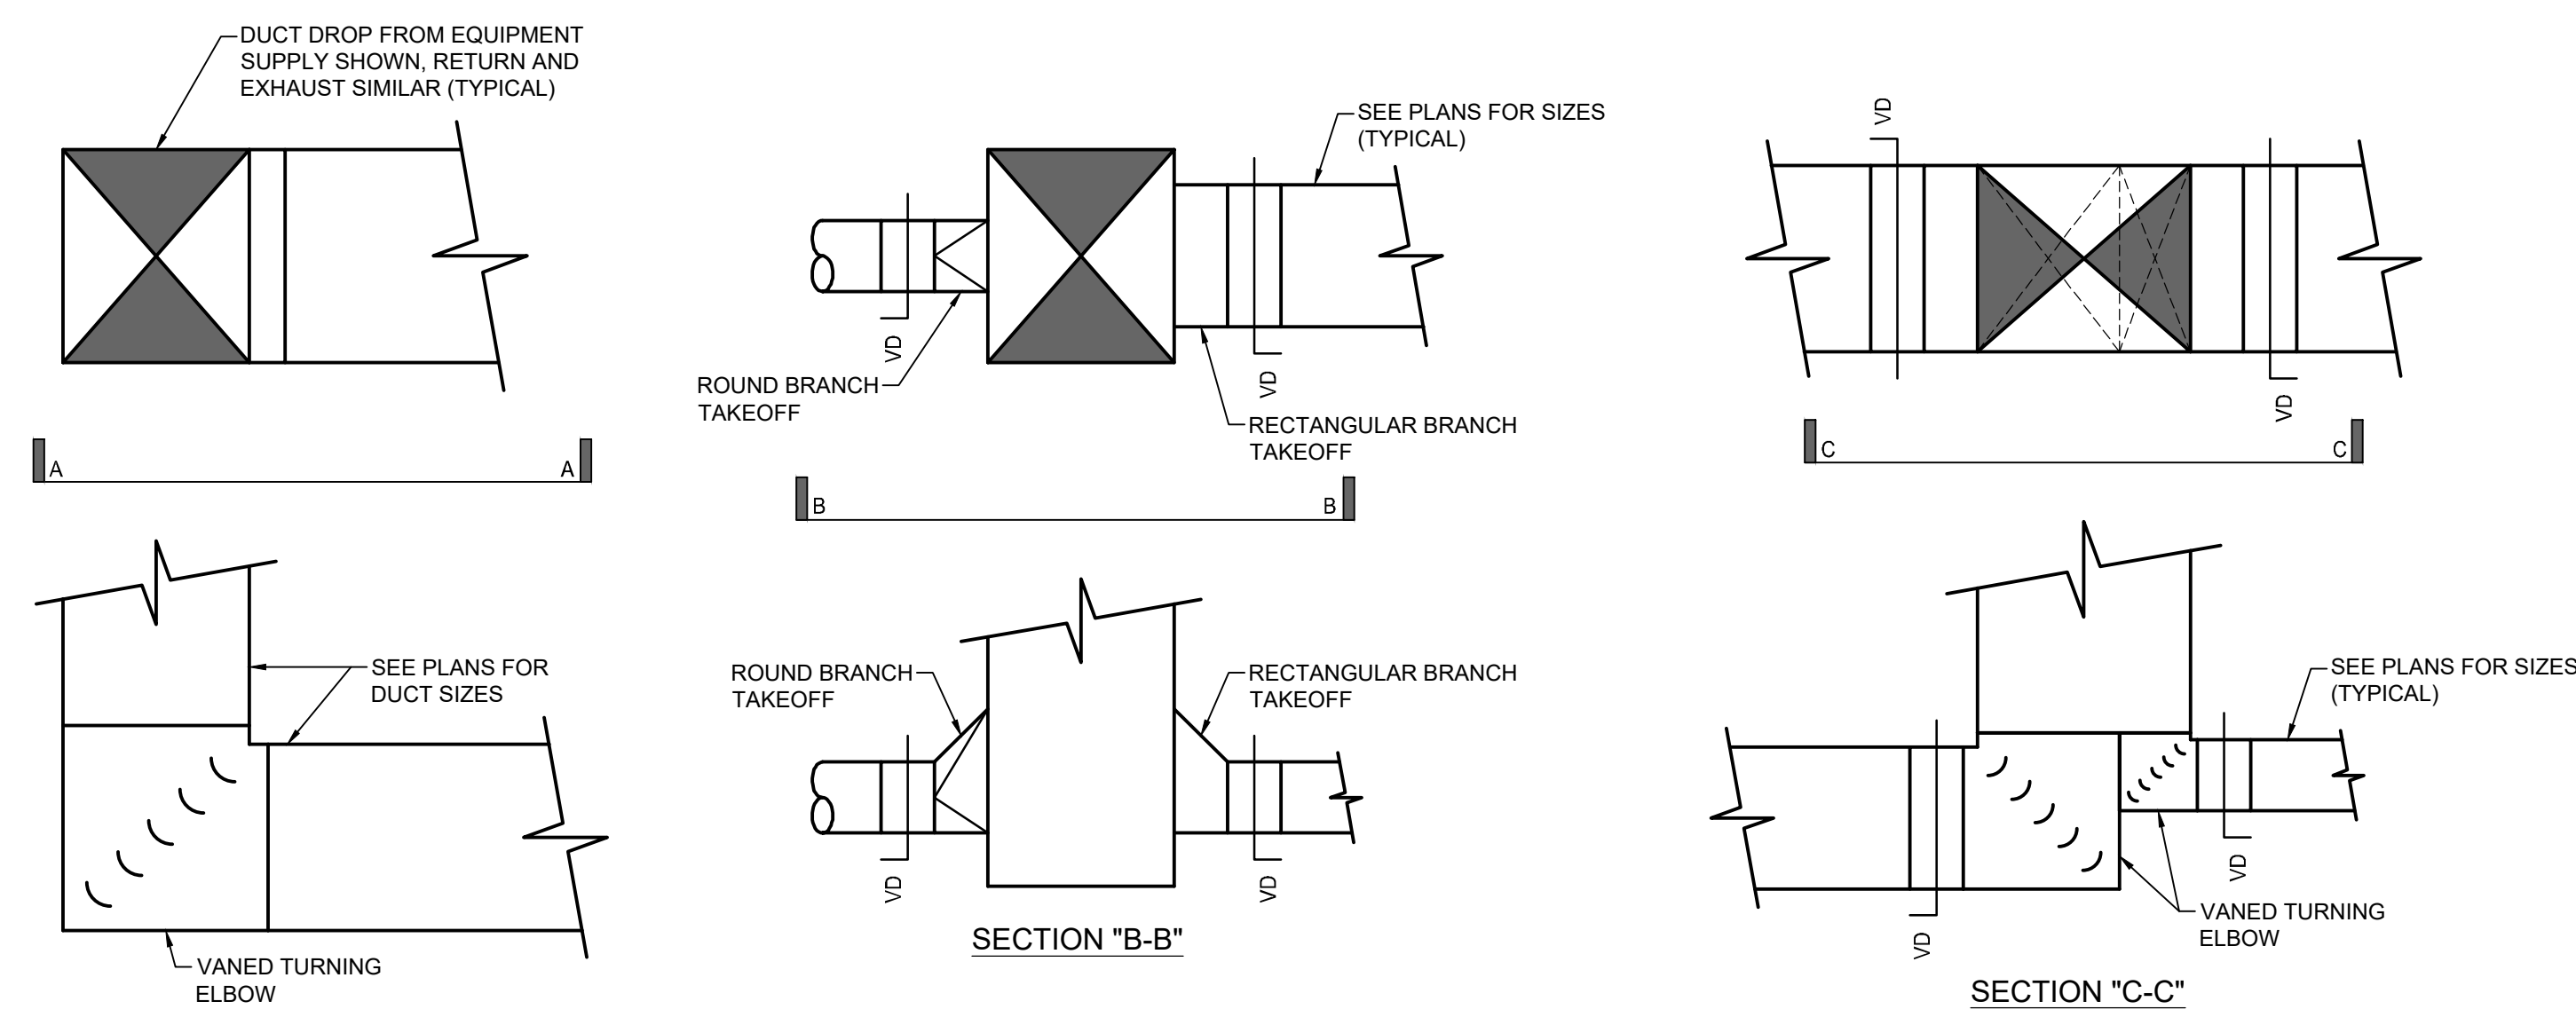


15 EQUIPMENT DUCT DROP DETAILS
SCALE: NONE

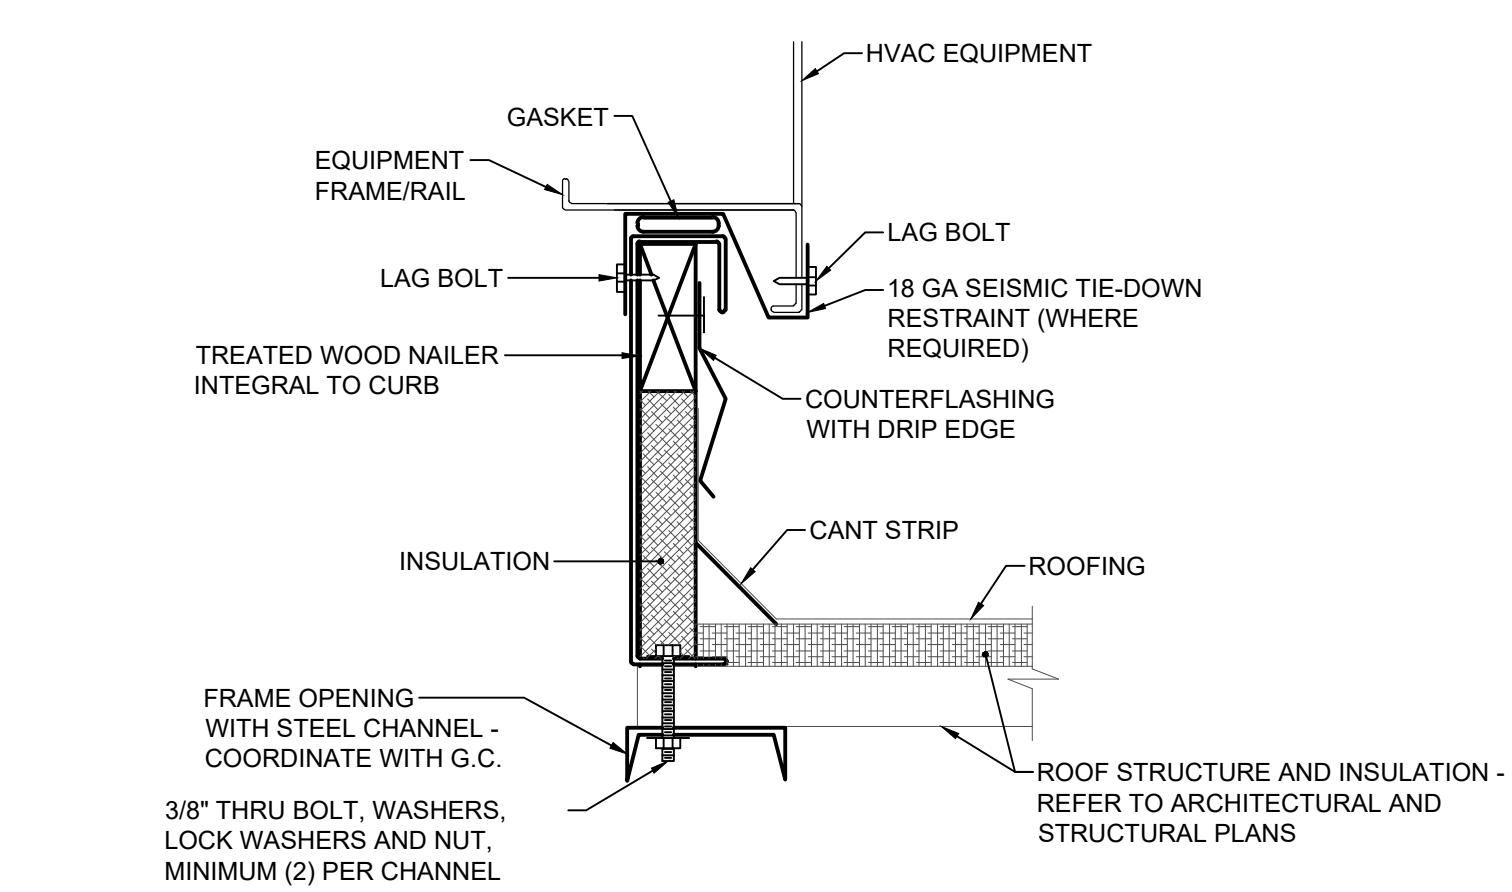


09 ROOFTOP UNIT CURB DETAIL
SCALE: NONE

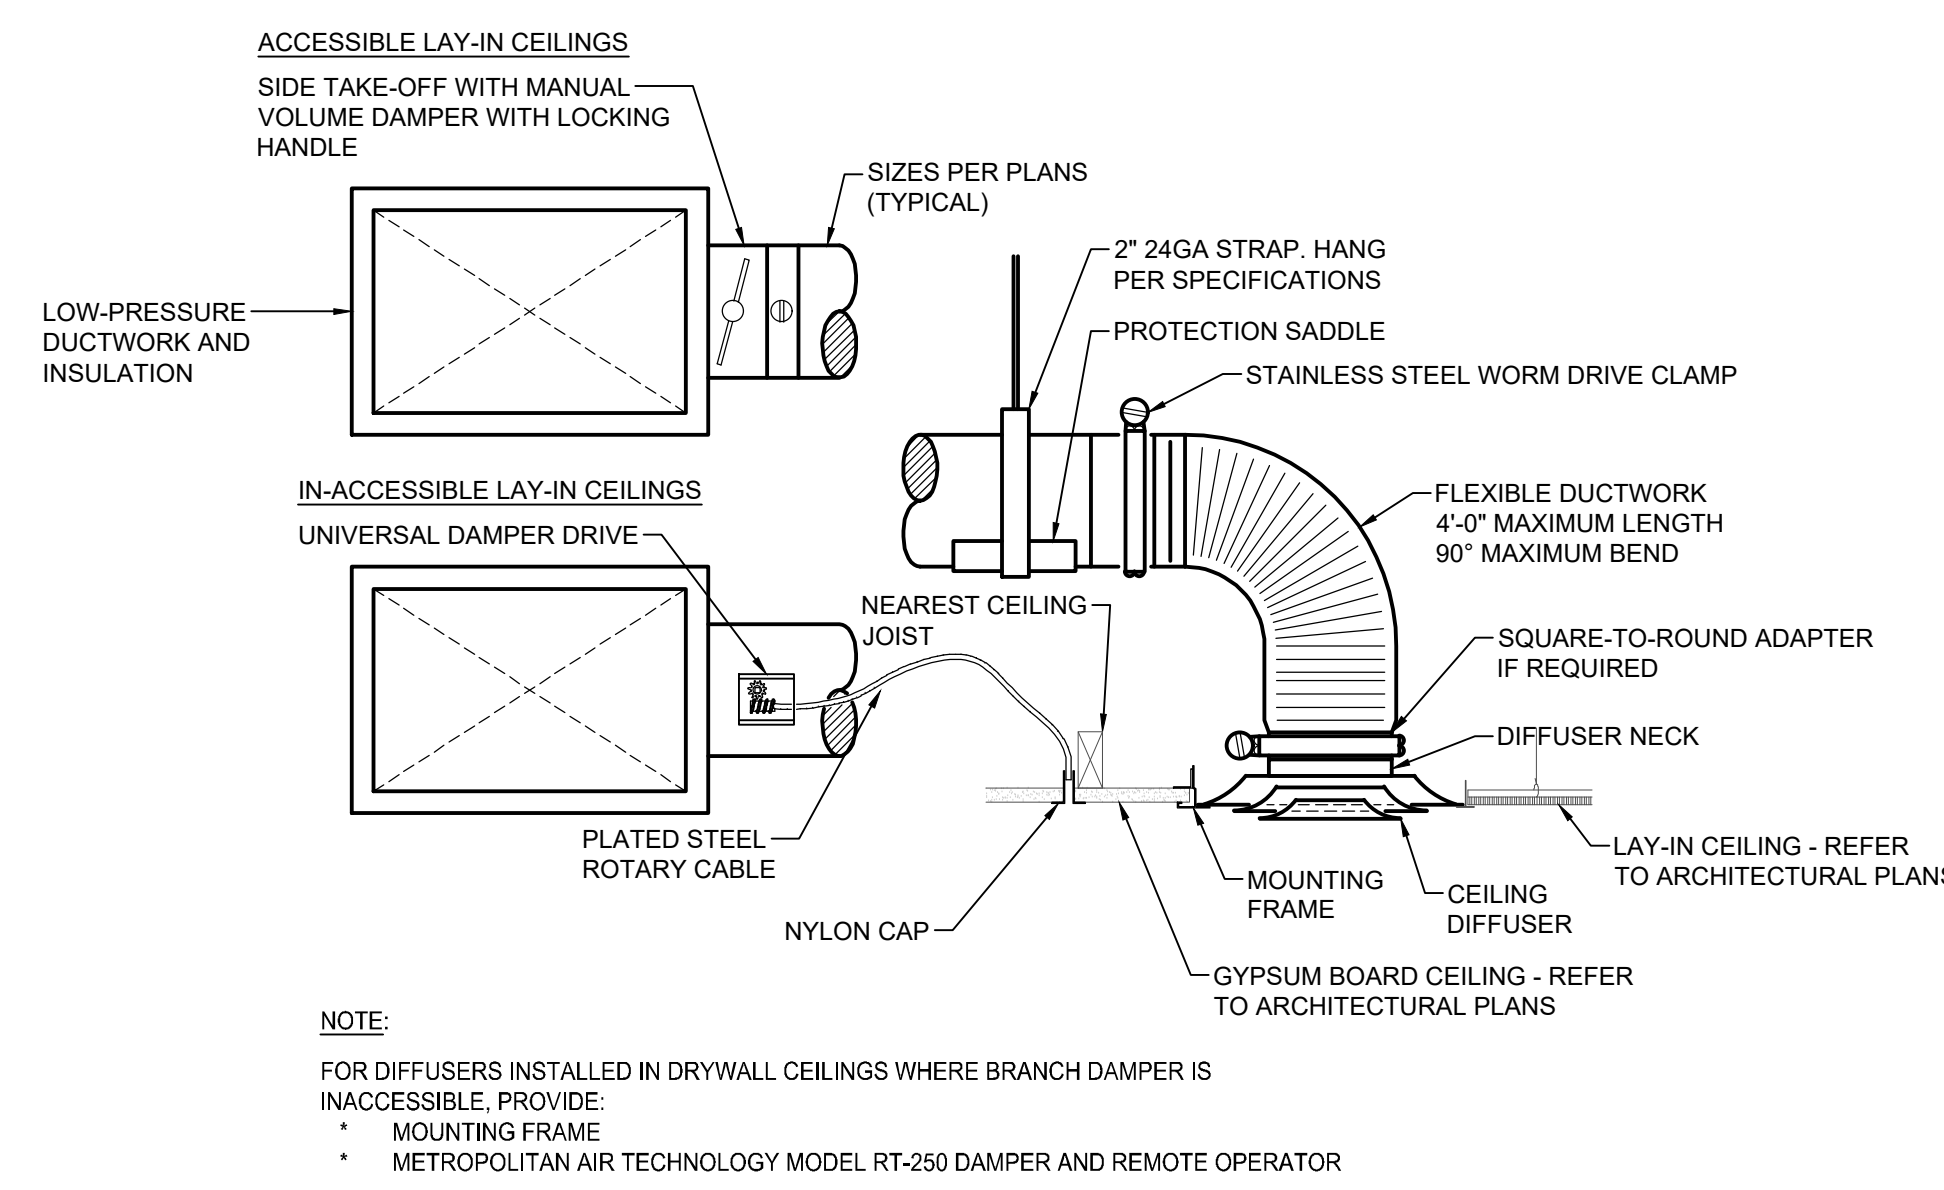


10 CEILING DIFFUSER DETAIL
SCALE: NONE

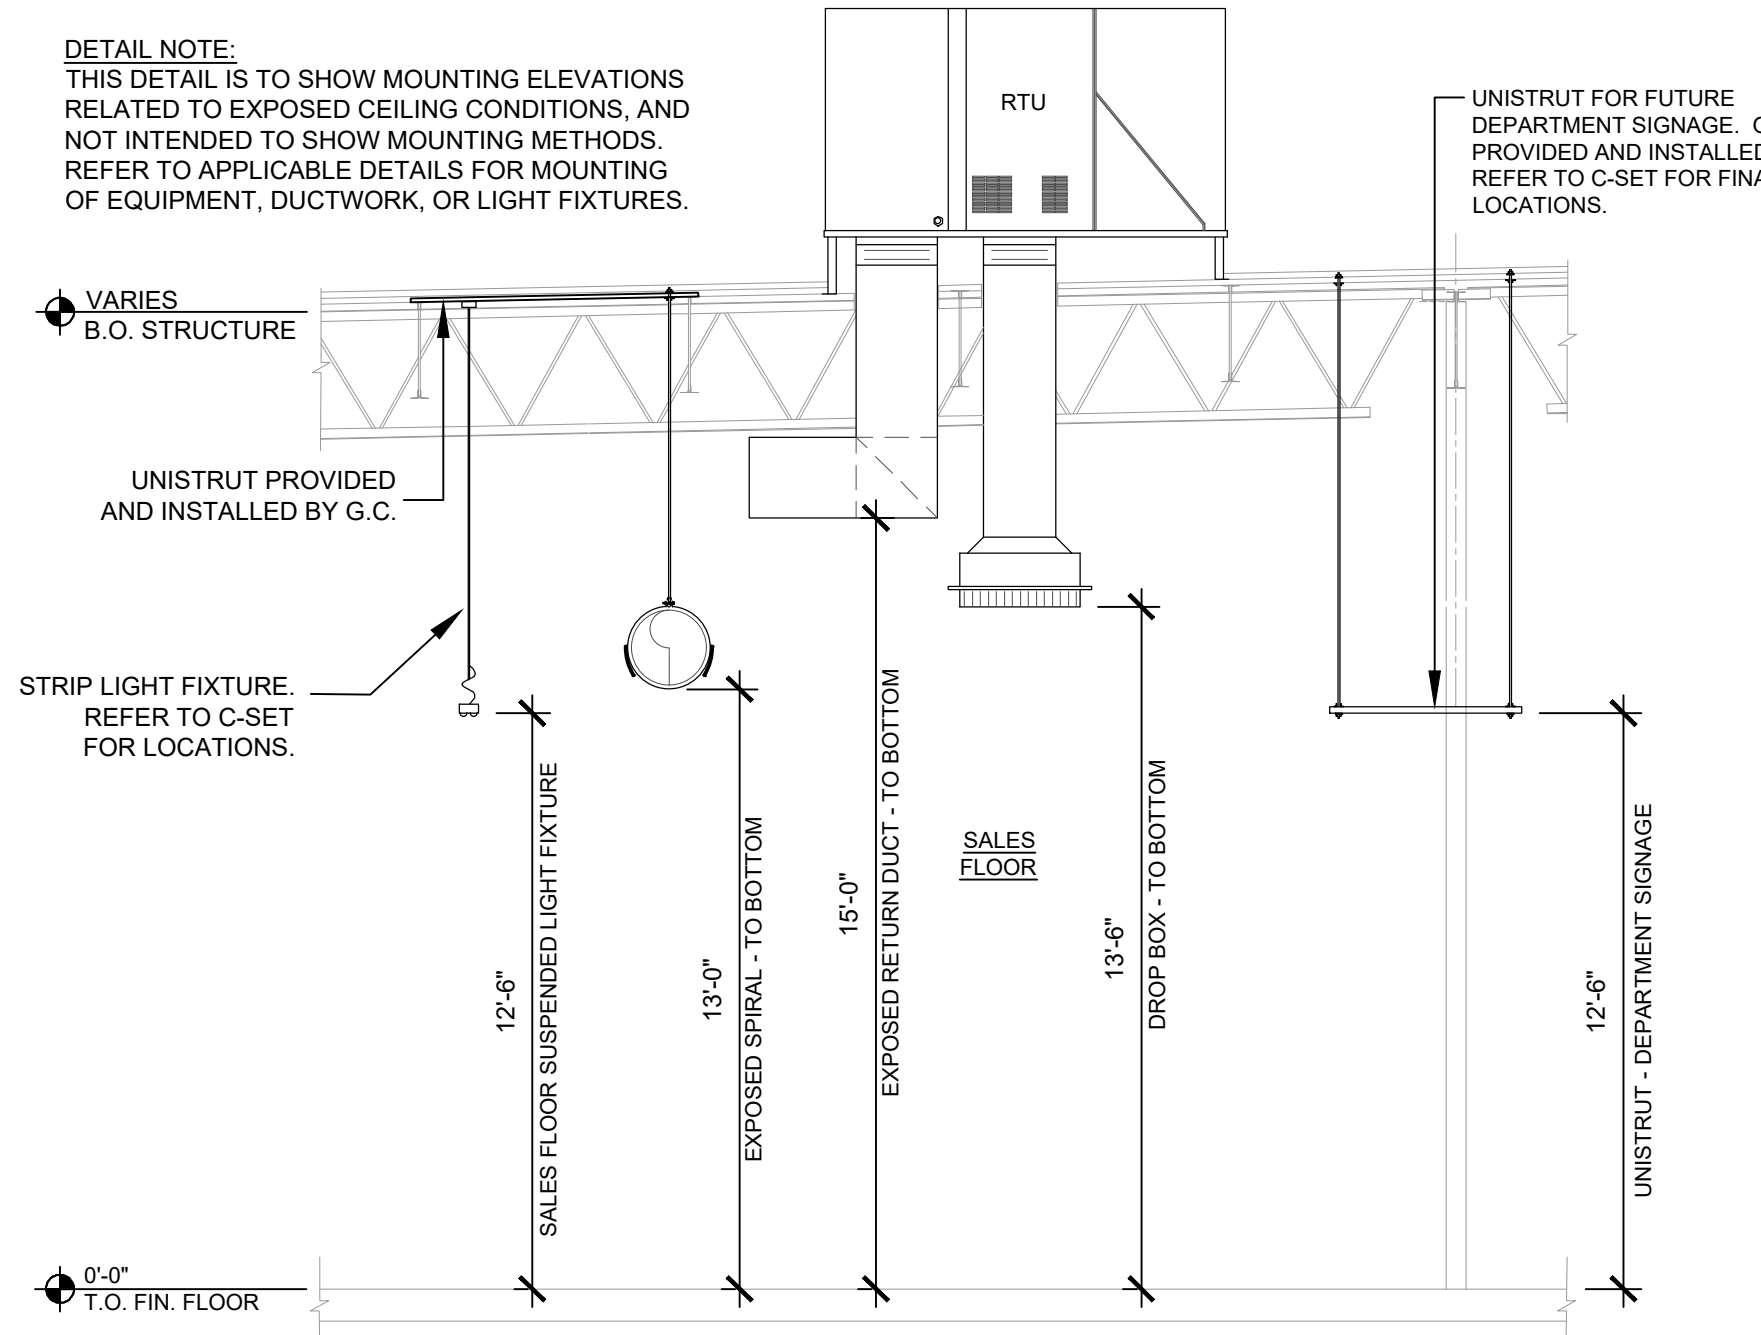


11 SALES FLOOR MOUNTING HEIGHTS
SCALE: NONE

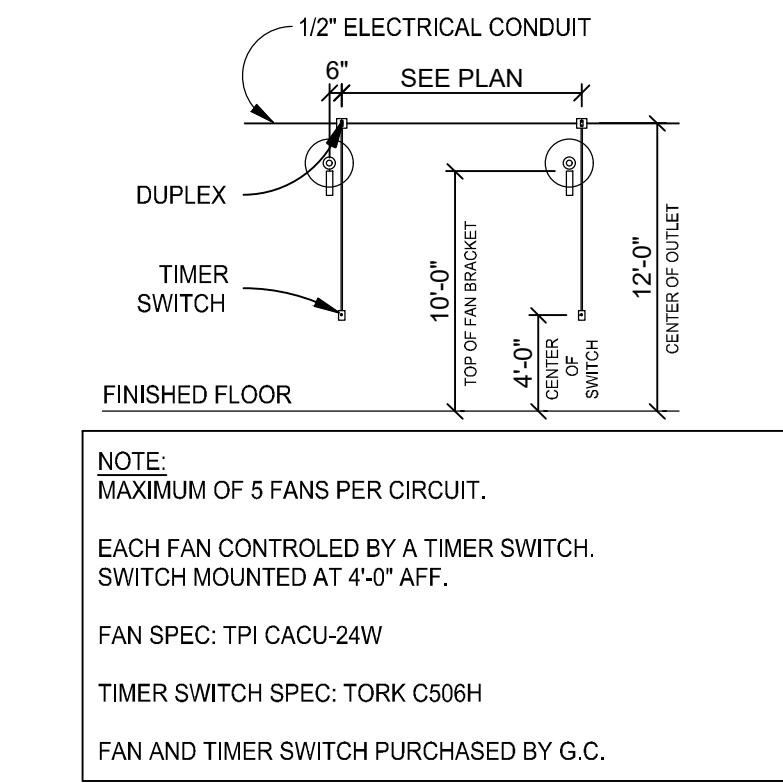


12 CIRCULATION FAN DETAILS
SCALE: NONE

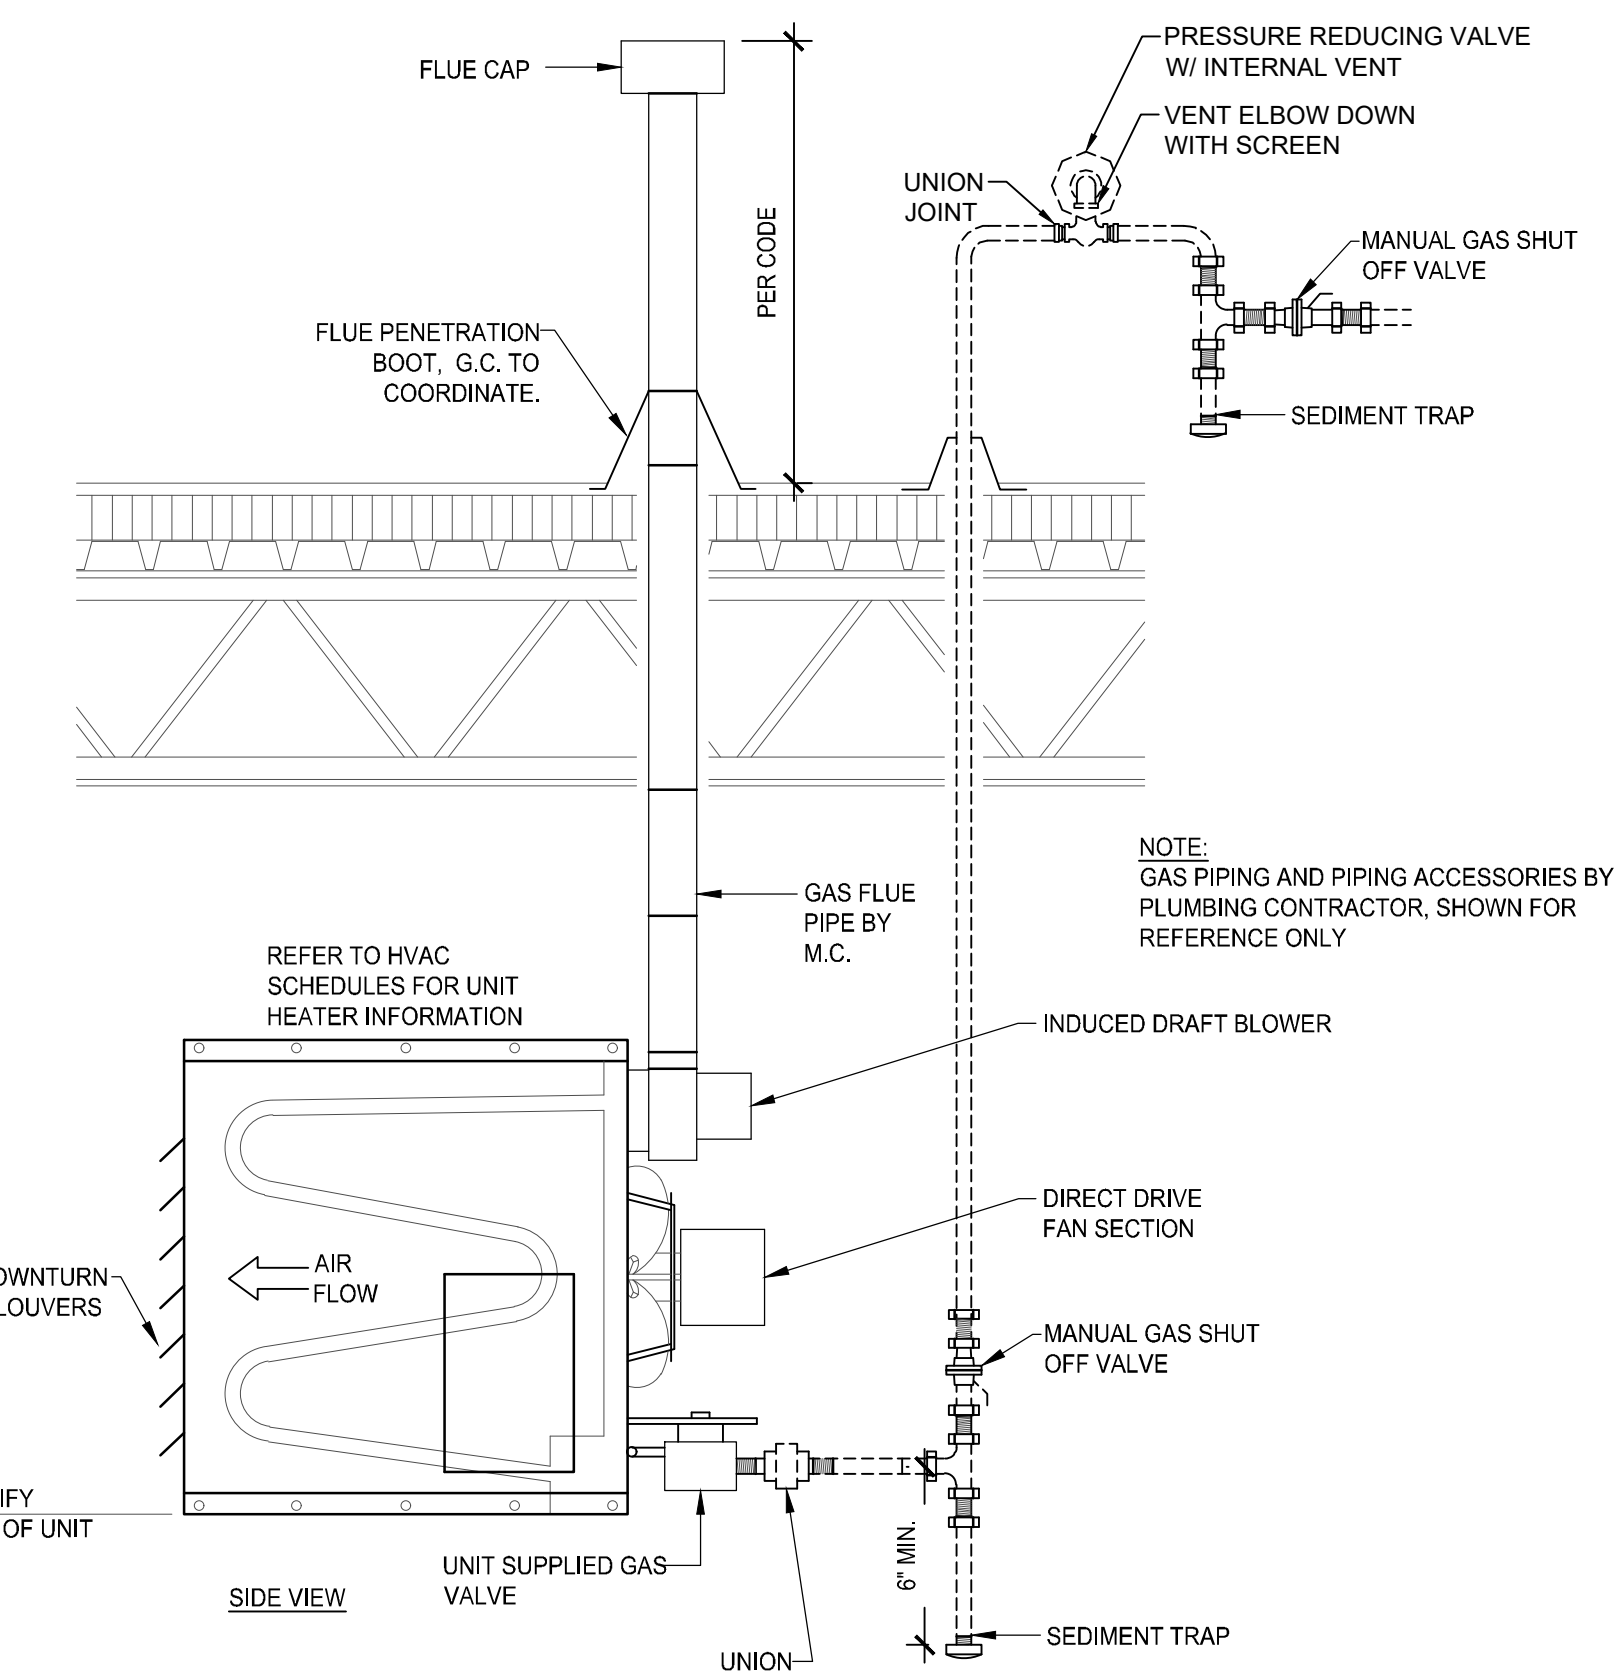


08 UNIT HEATER INSTALLATION DETAIL
SCALE: NONE

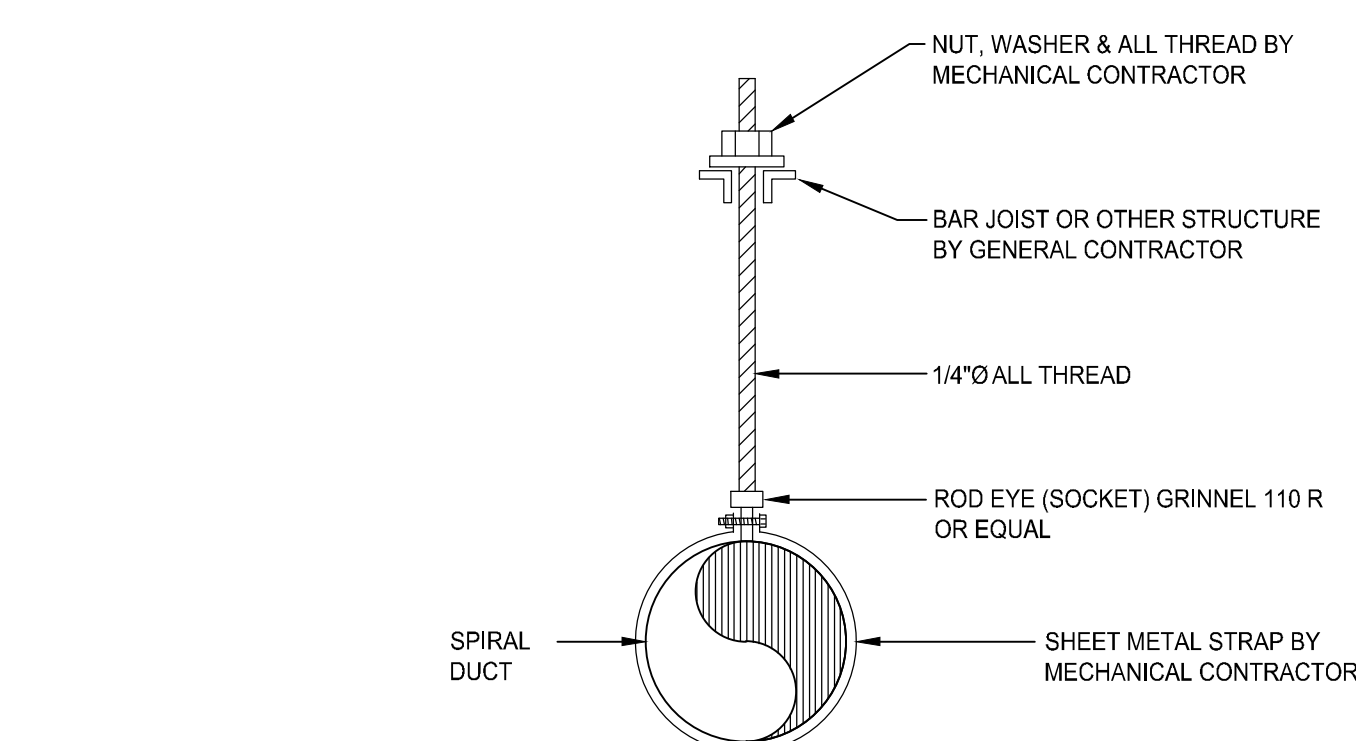


04 SPIRAL DUCT HANGER DETAIL
SCALE: NONE

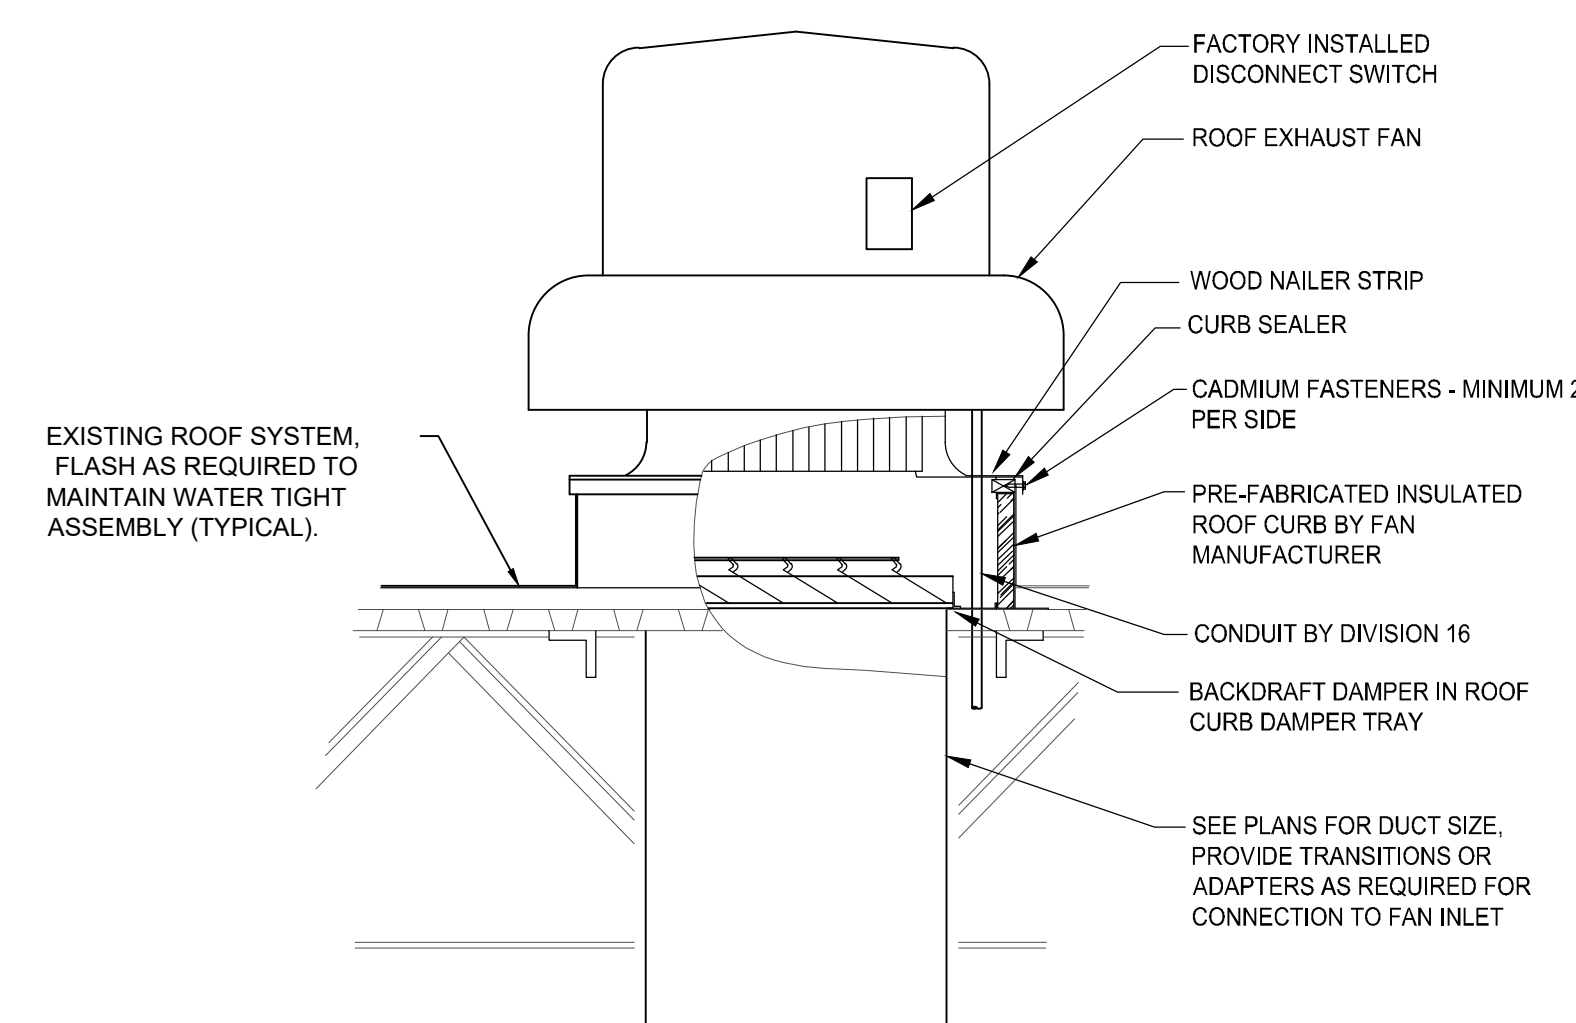


05 ROOF MOUNTED EXHAUST FAN DETAIL
SCALE: NONE

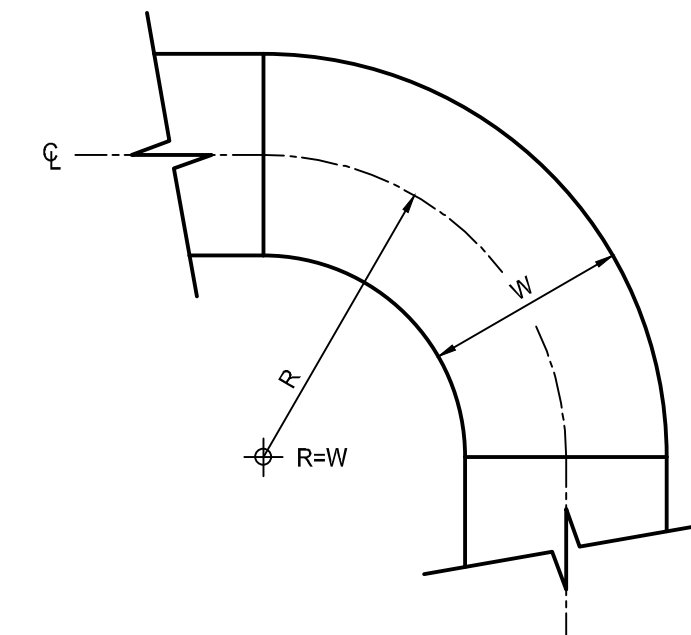


06 RADIUS ELBOW DETAIL
SCALE: NONE

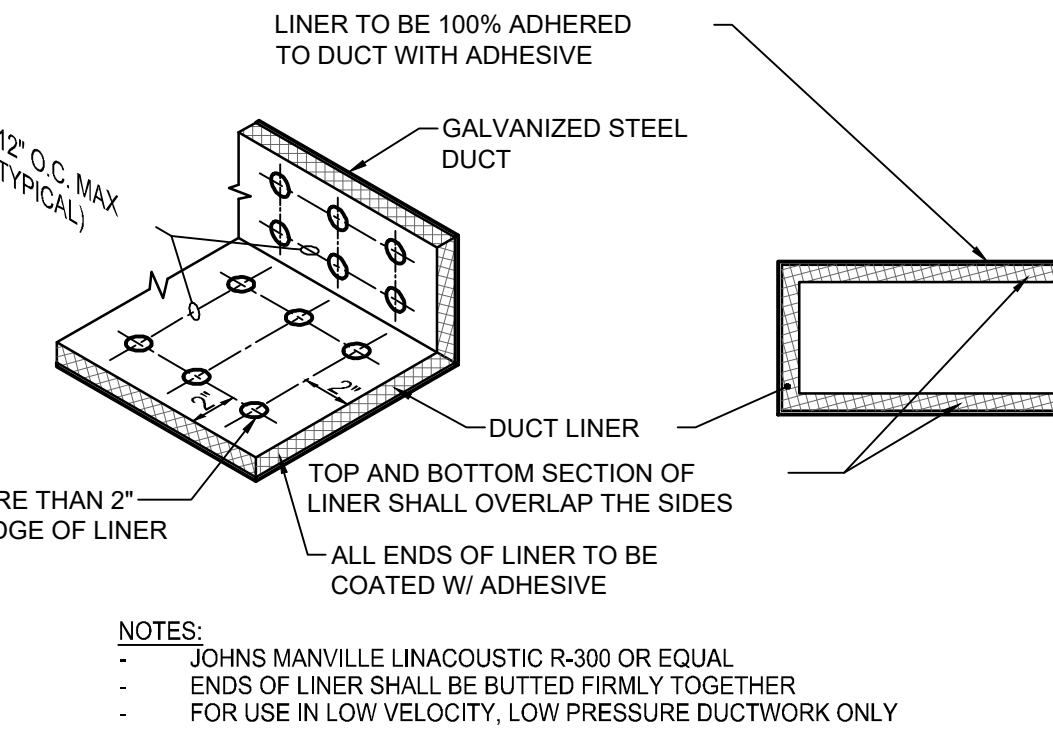


07 ACOUSTIC LINING DETAIL
SCALE: NONE

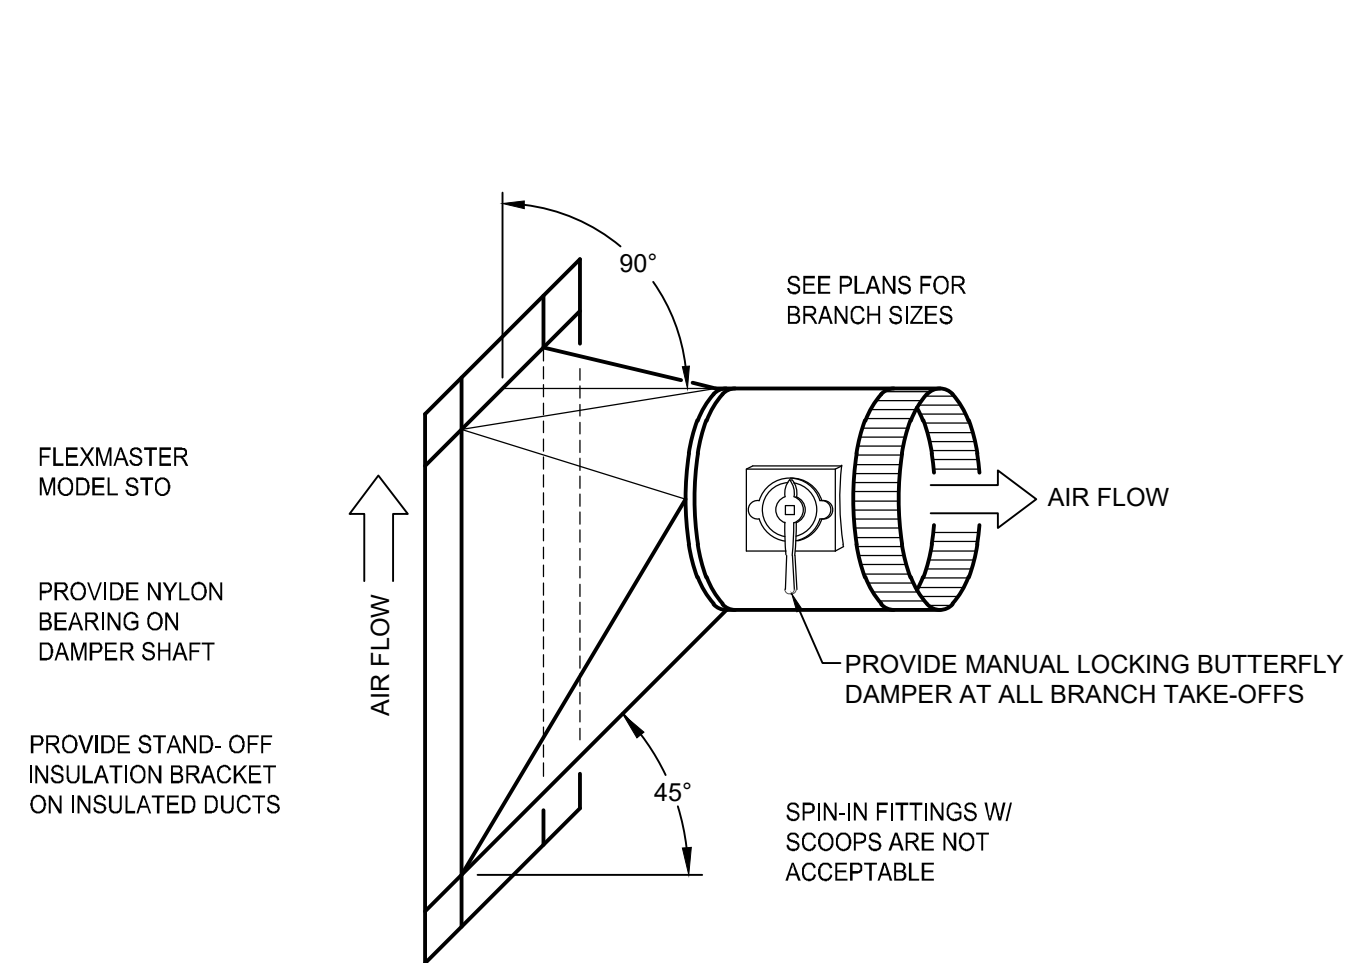

01 ROUND BRANCH TAKE-OFF
SCALE: NONE

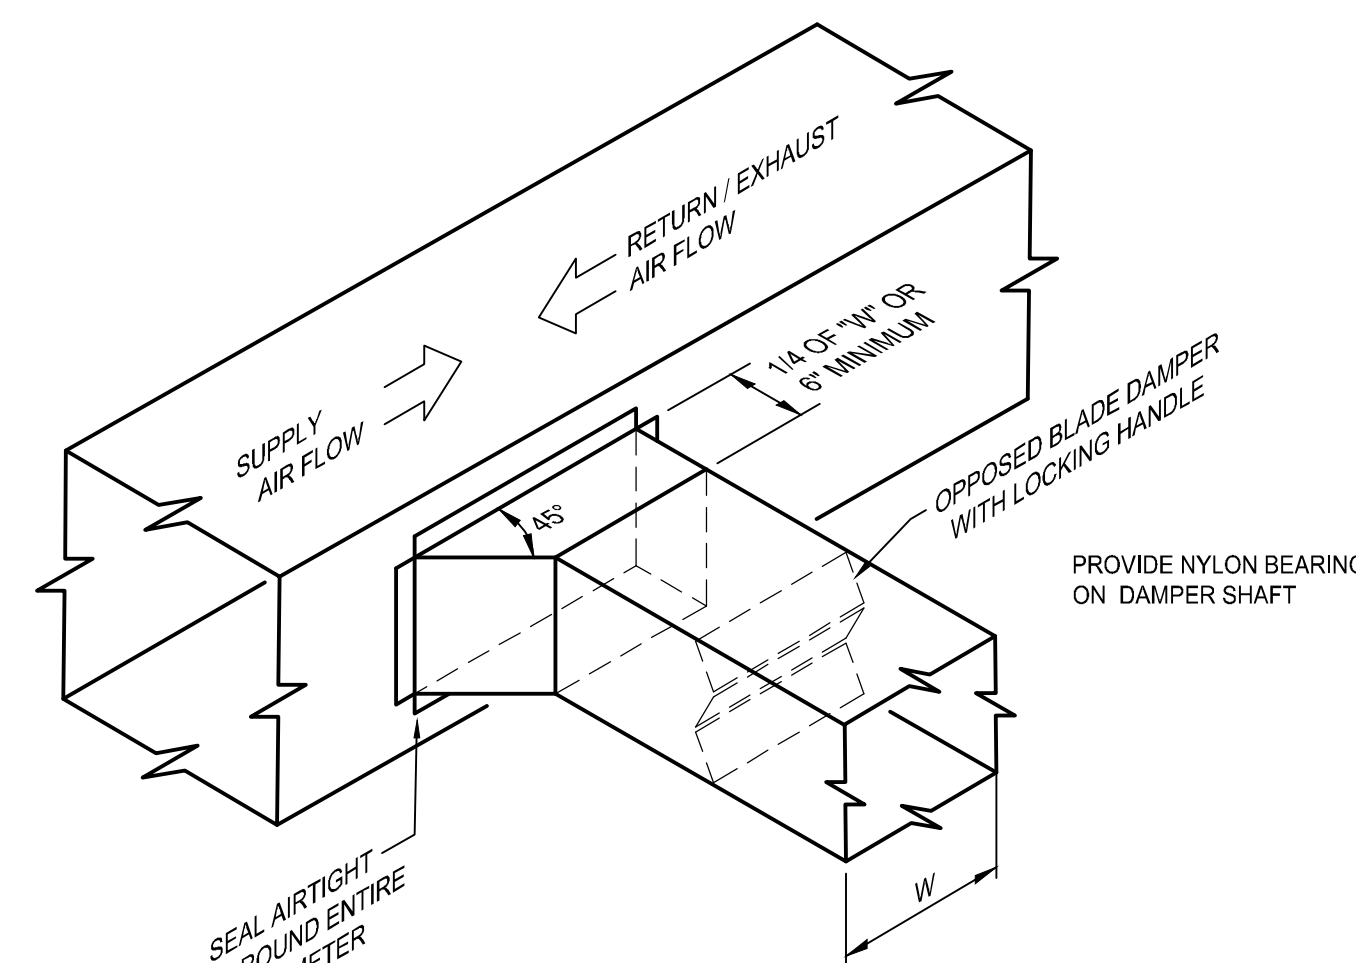

02 RECTANGULAR BRANCH TAKE-OFF
SCALE: NONE

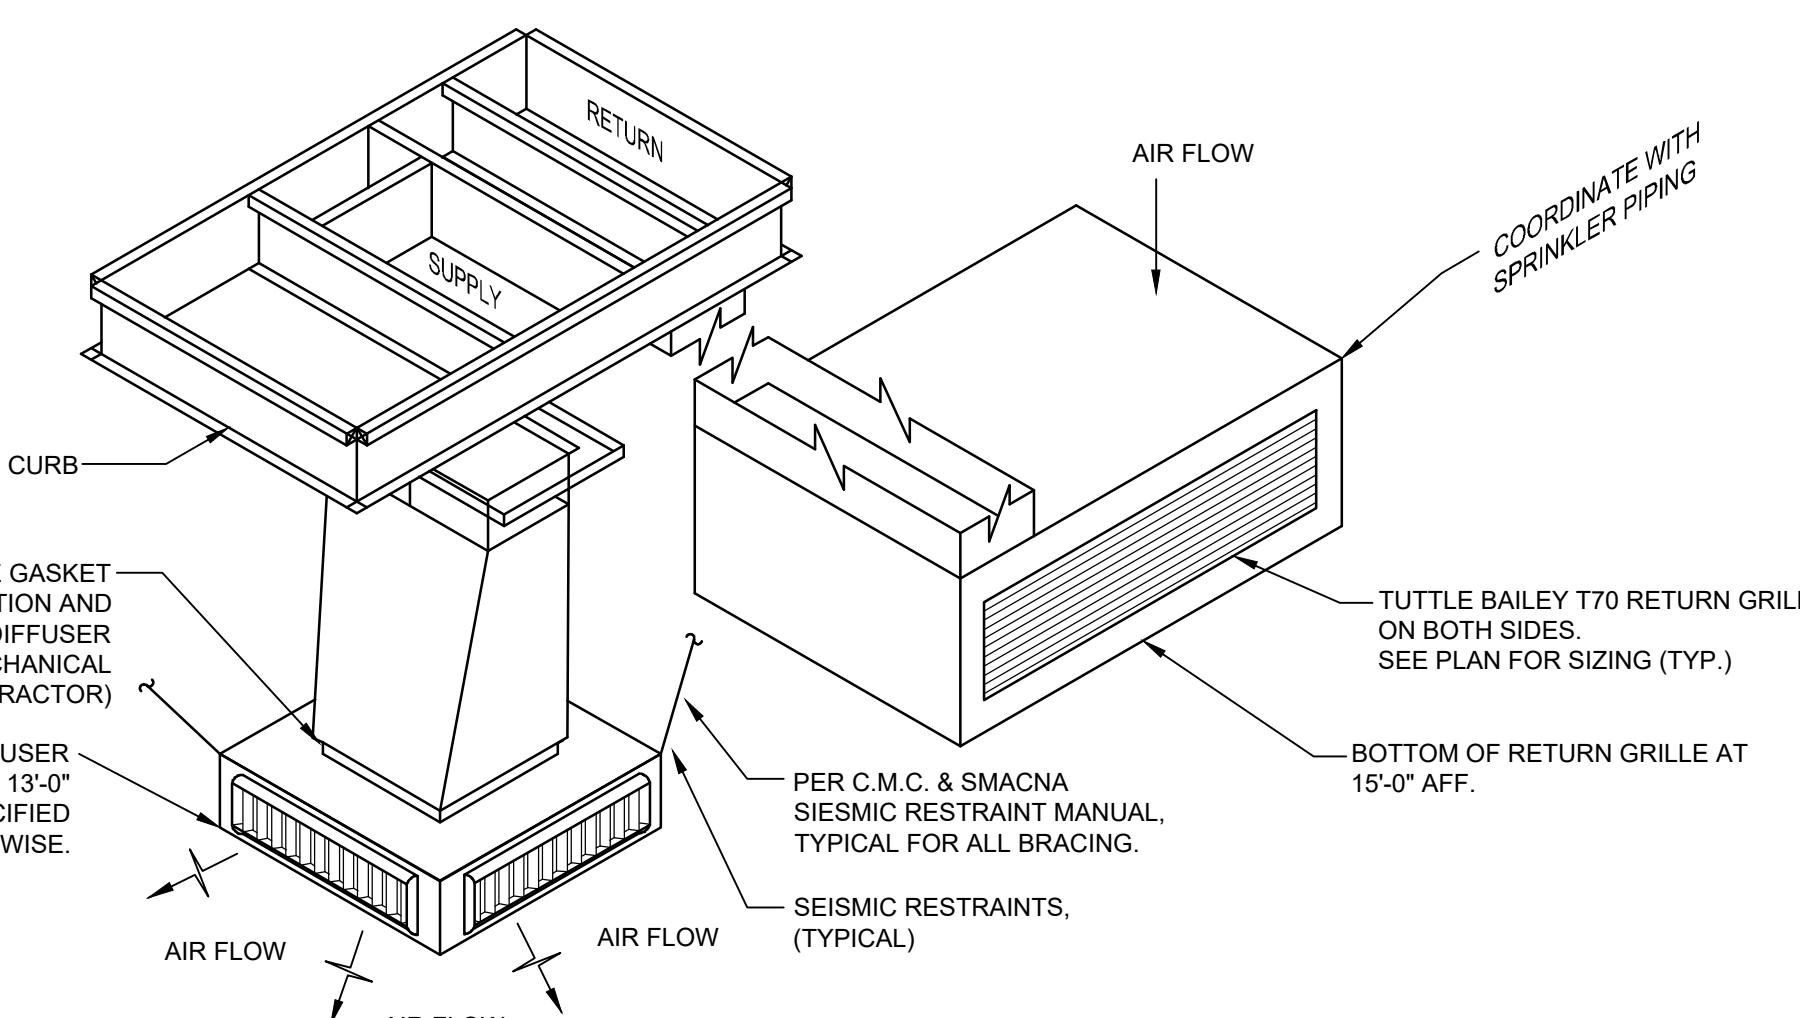

03 DRUM LOUVER DIFFUSER
SCALE: NONE

REVISION DATES

NO.	DATE	TYPE

ISSUE DATES

TYPE	DATE
TJX REVIEW	04/05/24

DRAWN BY

SP

CHECKED BY

JC

PROJECT NUMBER

23-04088

DATE

04/05/2024

SHEET TITLE

MECHANICAL DETAILS

SHEET NUMBER

M2

