


**H.E.S. SYSTEM**

MECHANICAL CONTRACTOR TO PROVIDE AND INSTALL SANOONAST H.E.S. SYSTEM FOR ALL NEW HOODS. SEE HOOD FAN/EQUIPMENT INTERLOCK WIRING DIAGRAM ON SHEET M41 FOR MORE INFORMATION.

EXISTING CONDITIONS SHOWN ARE FROM PREVIOUS DRAWINGS. MECHANICAL CONTRACTOR SHALL FIELD VERIFY ALL EXISTING CONDITIONS AND VERIFY ALL FIELD CONTACT CHECK-IT-A CONSTRUCTION MANAGER.

LOAD DUCT AT ACH1 & ACH6 AS HIGH AS POSSIBLE DUE TO LIMITED CLEARANCE ABOVE CEILING.

F14-425 TRANSFER GRILLES NO BALANCING DAMPER-

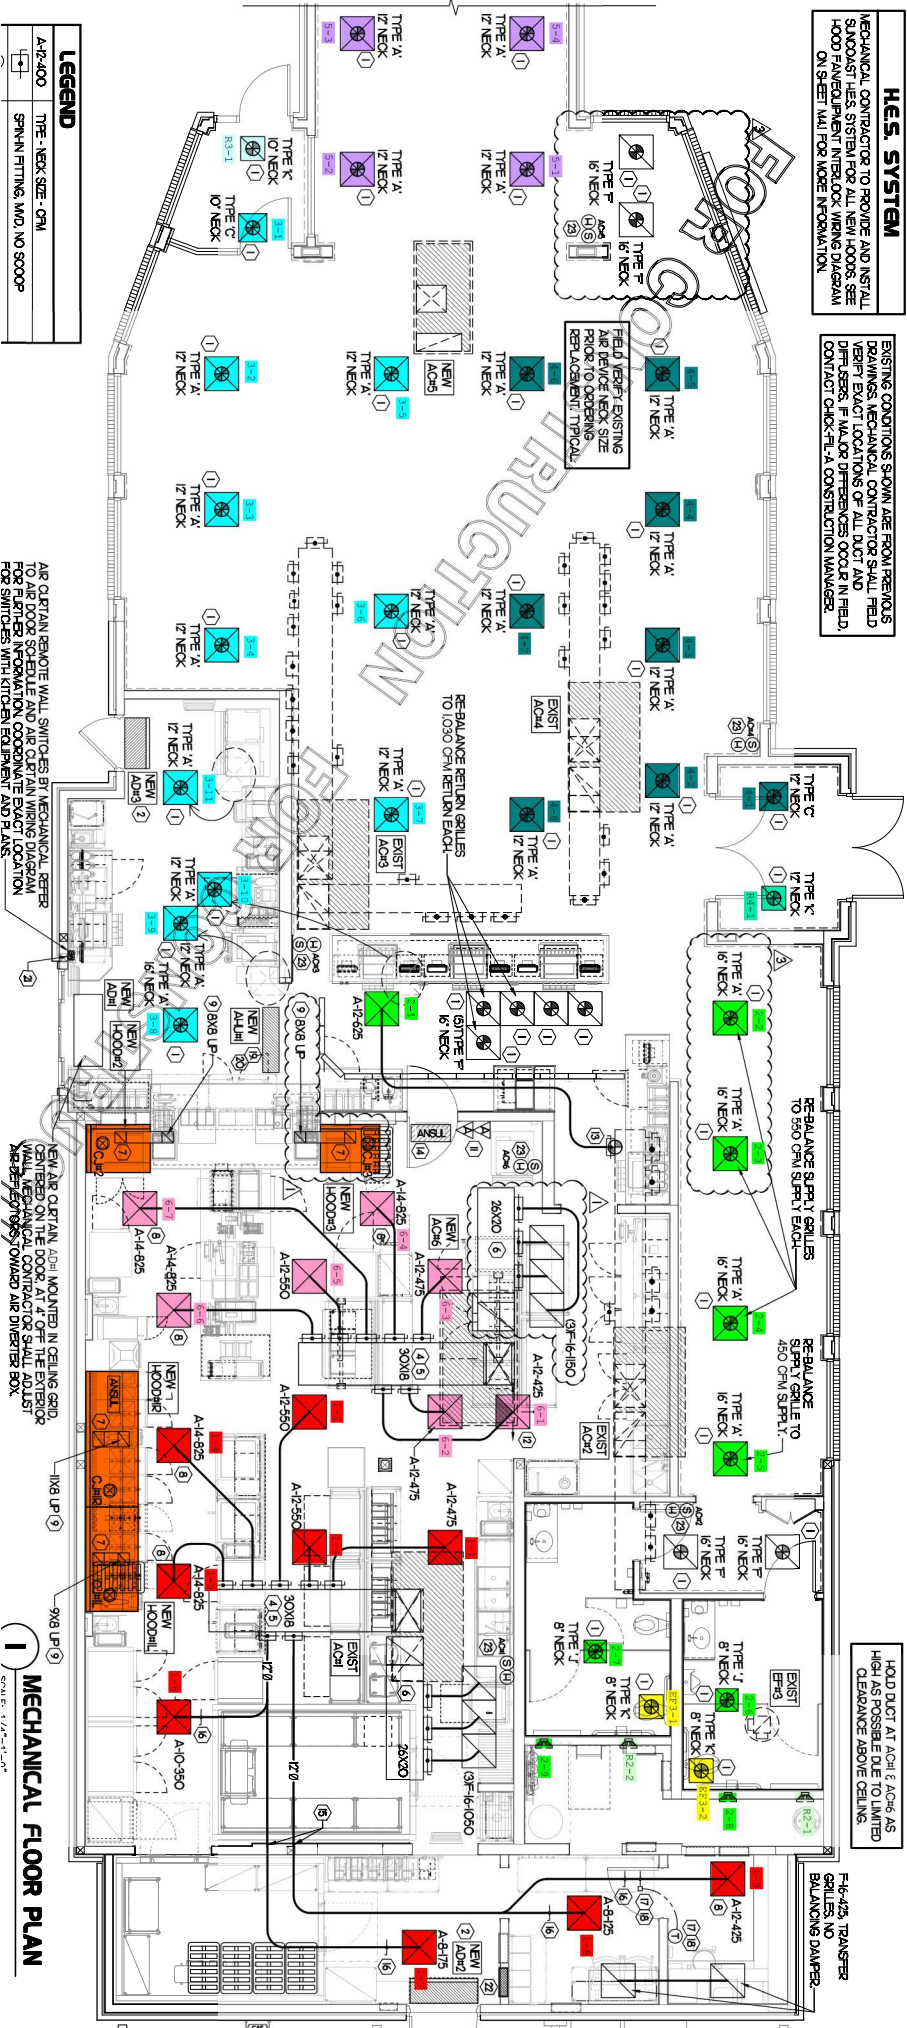

**LEGEND**

A-12-400	TYPE 'A' NECK SIZE - 091
SPN-H	FITTING, MTD, NO SCOOP

AIR CURTAIN BEHIND WALL SWITCHES BY MECHANICAL REFER TO AIR DOOR SCHEDULE AND AIR CURTAIN WIRING DIAGRAM FOR FLITER INFORMATION. COORDINATE EXACT LOCATION FOR SWITCHES WITH KITCHEN EQUIPMENT AND PLANS.

NEW AIR CURTAIN ACH1 MOUNTED IN CEILING GRID. CONTROLLED ON THE FLOOR AT A-12-475. THE EXTERIOR AIR DIRECTION TOWARD AIR DIRECTION BOX.

**MECHANICAL FLOOR PLAN**

SCALE: 1/4" = 1'-0"