

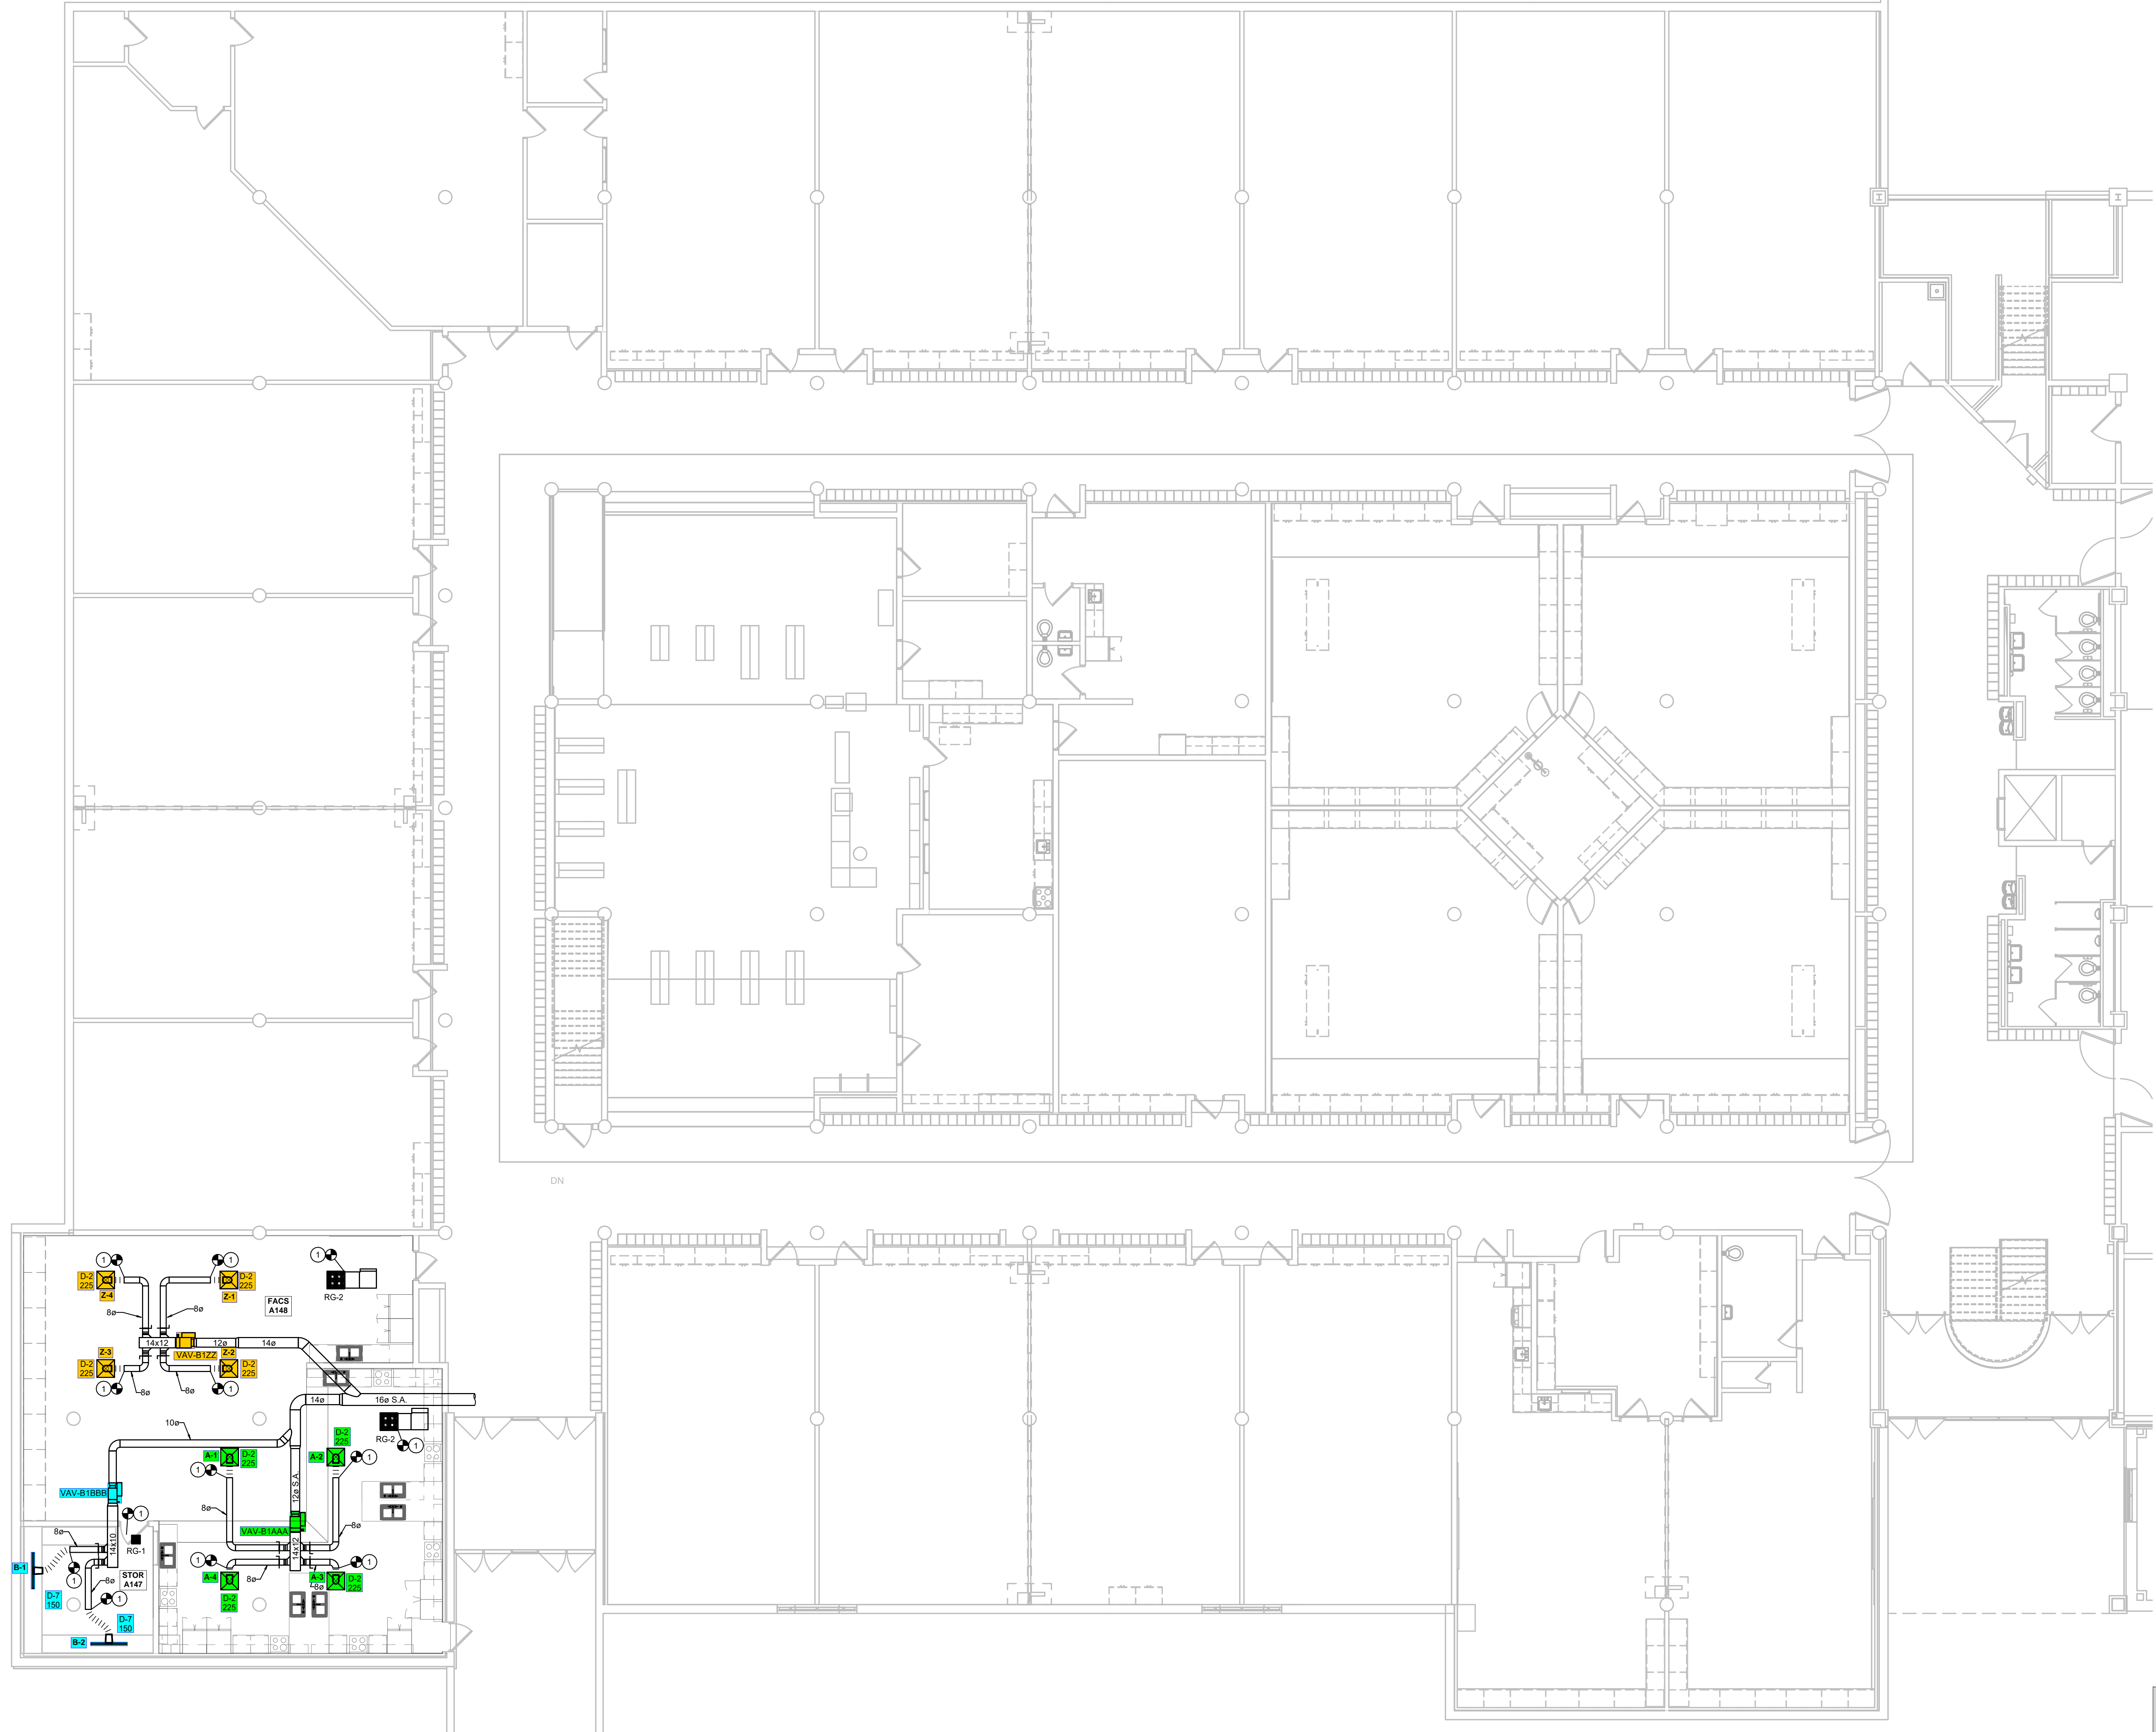
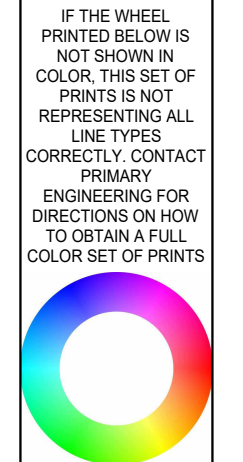


PLAN NOTES

1. PROVIDE AND INSTALL NEW DIFFUSER/GRILLE. CONNECT TO EXISTING DUCTWORK WITH NEW FLEX DUCT.

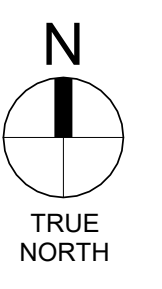

1 FIRST FLOOR - MECHANICAL PLAN - UNIT A
SCALE: 1/8" = 1'-0"

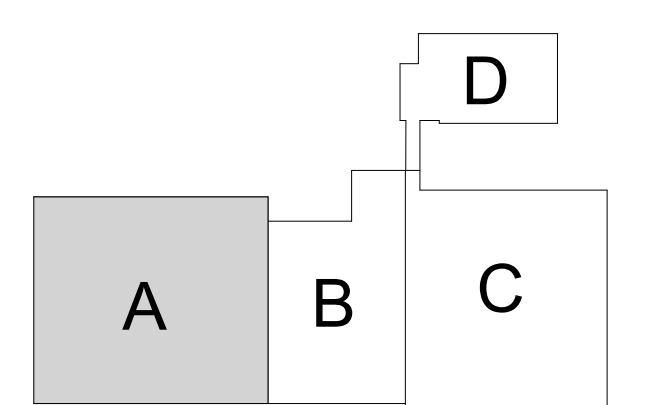

LANCER ASSOCIATES ARCHITECTURE
145 NORTH EAST STREET
INDIANAPOLIS, IN 46204

PRIMARY ENGINEERING INC.
Fort Wayne Indianapolis
2818 Law Ave. 8780 Crossport Blvd., Suite 103
Fort Wayne, Indiana 46802 Indianapolis, Indiana 46206
260.424.0644 ph indianapolis@primaryeng.com 317.224.1221 ph
www.primaryeng.com www.primaryeng.com

All concepts, ideas, plans, and details as shown on this document are the sole property of Primary Engineering, Inc. and shall not be used for any other purpose without their expressed written consent. The project owner shall be permitted to retain copies for information and reference purposes.
©2024 © Primary Engineering, Inc.

**SUNMAN-DEARBORN COMMUNITY SCHOOLS
EAST CENTRAL MIDDLE SCHOOL RENOVATIONS**
8356 SCHUMAN RD, BROOKVILLE, IN 47012



[Signature]

REVISIONS:	#	DATE	DESC.

IFS SET

PROJECT: #23138
DATE: 11/25/2024
DRAWN BY: ASL

FIRST FLOOR - MECHANICAL PLAN - UNIT A

M101A

PRIMARY JOB # 24584

