


2641 IRVING BLVD.
DALLAS, TEXAS 75207
TEL: 214-636-6800

ARCHITECT/ENGINEER

Purdy - McGuire
Professional - Electrical Engineers
17300 North Dallas Parkway
Suite 3000
Dallas, Texas 75248-1147
Firm Registration # F-1511
Tel: 972-239-5357
Fax: 972-239-5231
www.purdy-mcguire.com

© 2024
PMI JOB NO. 24079.002
PROJECT MGR. TODD JOHNSON
THIS DRAWING SHALL NOT BE REPRODUCED FOR ANY PROJECT OTHER THAN THE PROJECT NOTED IN THE TITLE BLOCK, WITHOUT THE WRITTEN CONSENT OF PURDY-MCGUIRE, INC. DALLAS, TX

SEAL

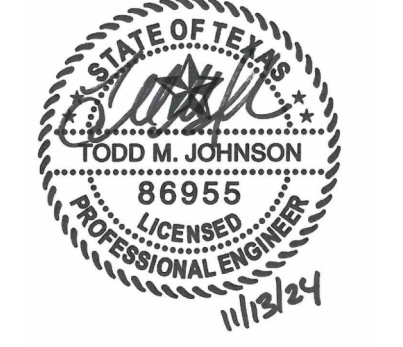

PROJECT NUMBER: 521-015
DRAWN BY: BH
CHECKED BY: KS
R.S.F.: 13,538

BILLINGSLEY COMPANY

INTERNATIONAL BUSINESS PARK
ARGANO

6111 W. PLANO PARKWAY
SUITE # 1500
PLANO, TX 75063

Table with columns: NO., REVISIONS, DATE. Contains a grid for tracking revisions.

CLIENT/LANDLORD ISSUE DATE: 11/13/2024
BID ISSUE DATE: 11/13/2024
PERMIT ISSUE DATE: 11/13/2024

DRAWING TITLE:
LEVEL 01 MECHANICAL PLAN


DRAWING NUMBER:
M2.01

© 2024 idGROUP, LLC

NOTES BY SYMBOL:

1. RELOCATE EXISTING THERMOSTAT TO NEW LOCATION AS SHOWN ON PLAN. CONFIRM THAT THE THERMOSTATS ARE ASSOCIATED WITH THE TERMINAL BOX AS SHOWN ON THE DRAWING BEFORE RELOCATING AND ARE IN WORKING ORDER.
2. PROVIDE ACOUSTICALLY LINED RETURN AIR BOOT THRU WALL TO DECK AS HIGH AS POSSIBLE ABOVE CEILING WITH INLET ELBOW AND OUTLET 90° ELBOW FACING UPWARD. SIZE PER PLANS. REFER TO DETAIL SHEET M0.01 FOR MORE INFORMATION.
3. NEW LOCATION OF TERMINAL BOX. MOUNT BOX FROM STRUCTURE ABOVE. ENSURE BOX CLEARANCES ARE MAINTAINED AT NEW LOCATION. EXTEND NEW MEDIUM AND LOW PRESSURE DUCT AS INDICATED ON DRAWINGS. COORDINATE RELOCATION WITH OTHER TRADES INVOLVED.
4. EXTEND NEW FULL SIZE DUCT SAME SIZE AND MATERIALS TO MATCH EXISTING DUCT. VERIFY SIZE AT JOB SITE PRIOR TO BIDDING.
5. EXHAUST FAN TO BE MOUNTED AT CEILING AND SUSPENDED FROM STRUCTURE WITH ISOLATION SPRINGS. EXTEND EXHAUST DUCT AS INDICATED ON DRAWINGS.
6. EXPANDED TAP. REFER TO DETAIL ON SHEET M0.01.
7. PROVIDE RETURN AIR OPENING HIGH AS POSSIBLE ABOVE SUSPENDED CEILING. ENSURE SIZE OF OPENING MATCHES EXISTING OPENINGS OF RETURN AIR TRANSFER DUCT FROM ADJACENT TENANT ACROSS THE CORRIDOR.

REFER TO SHEET M0.01 FOR GENERAL NOTES, SCHEDULES AND SYMBOLS.

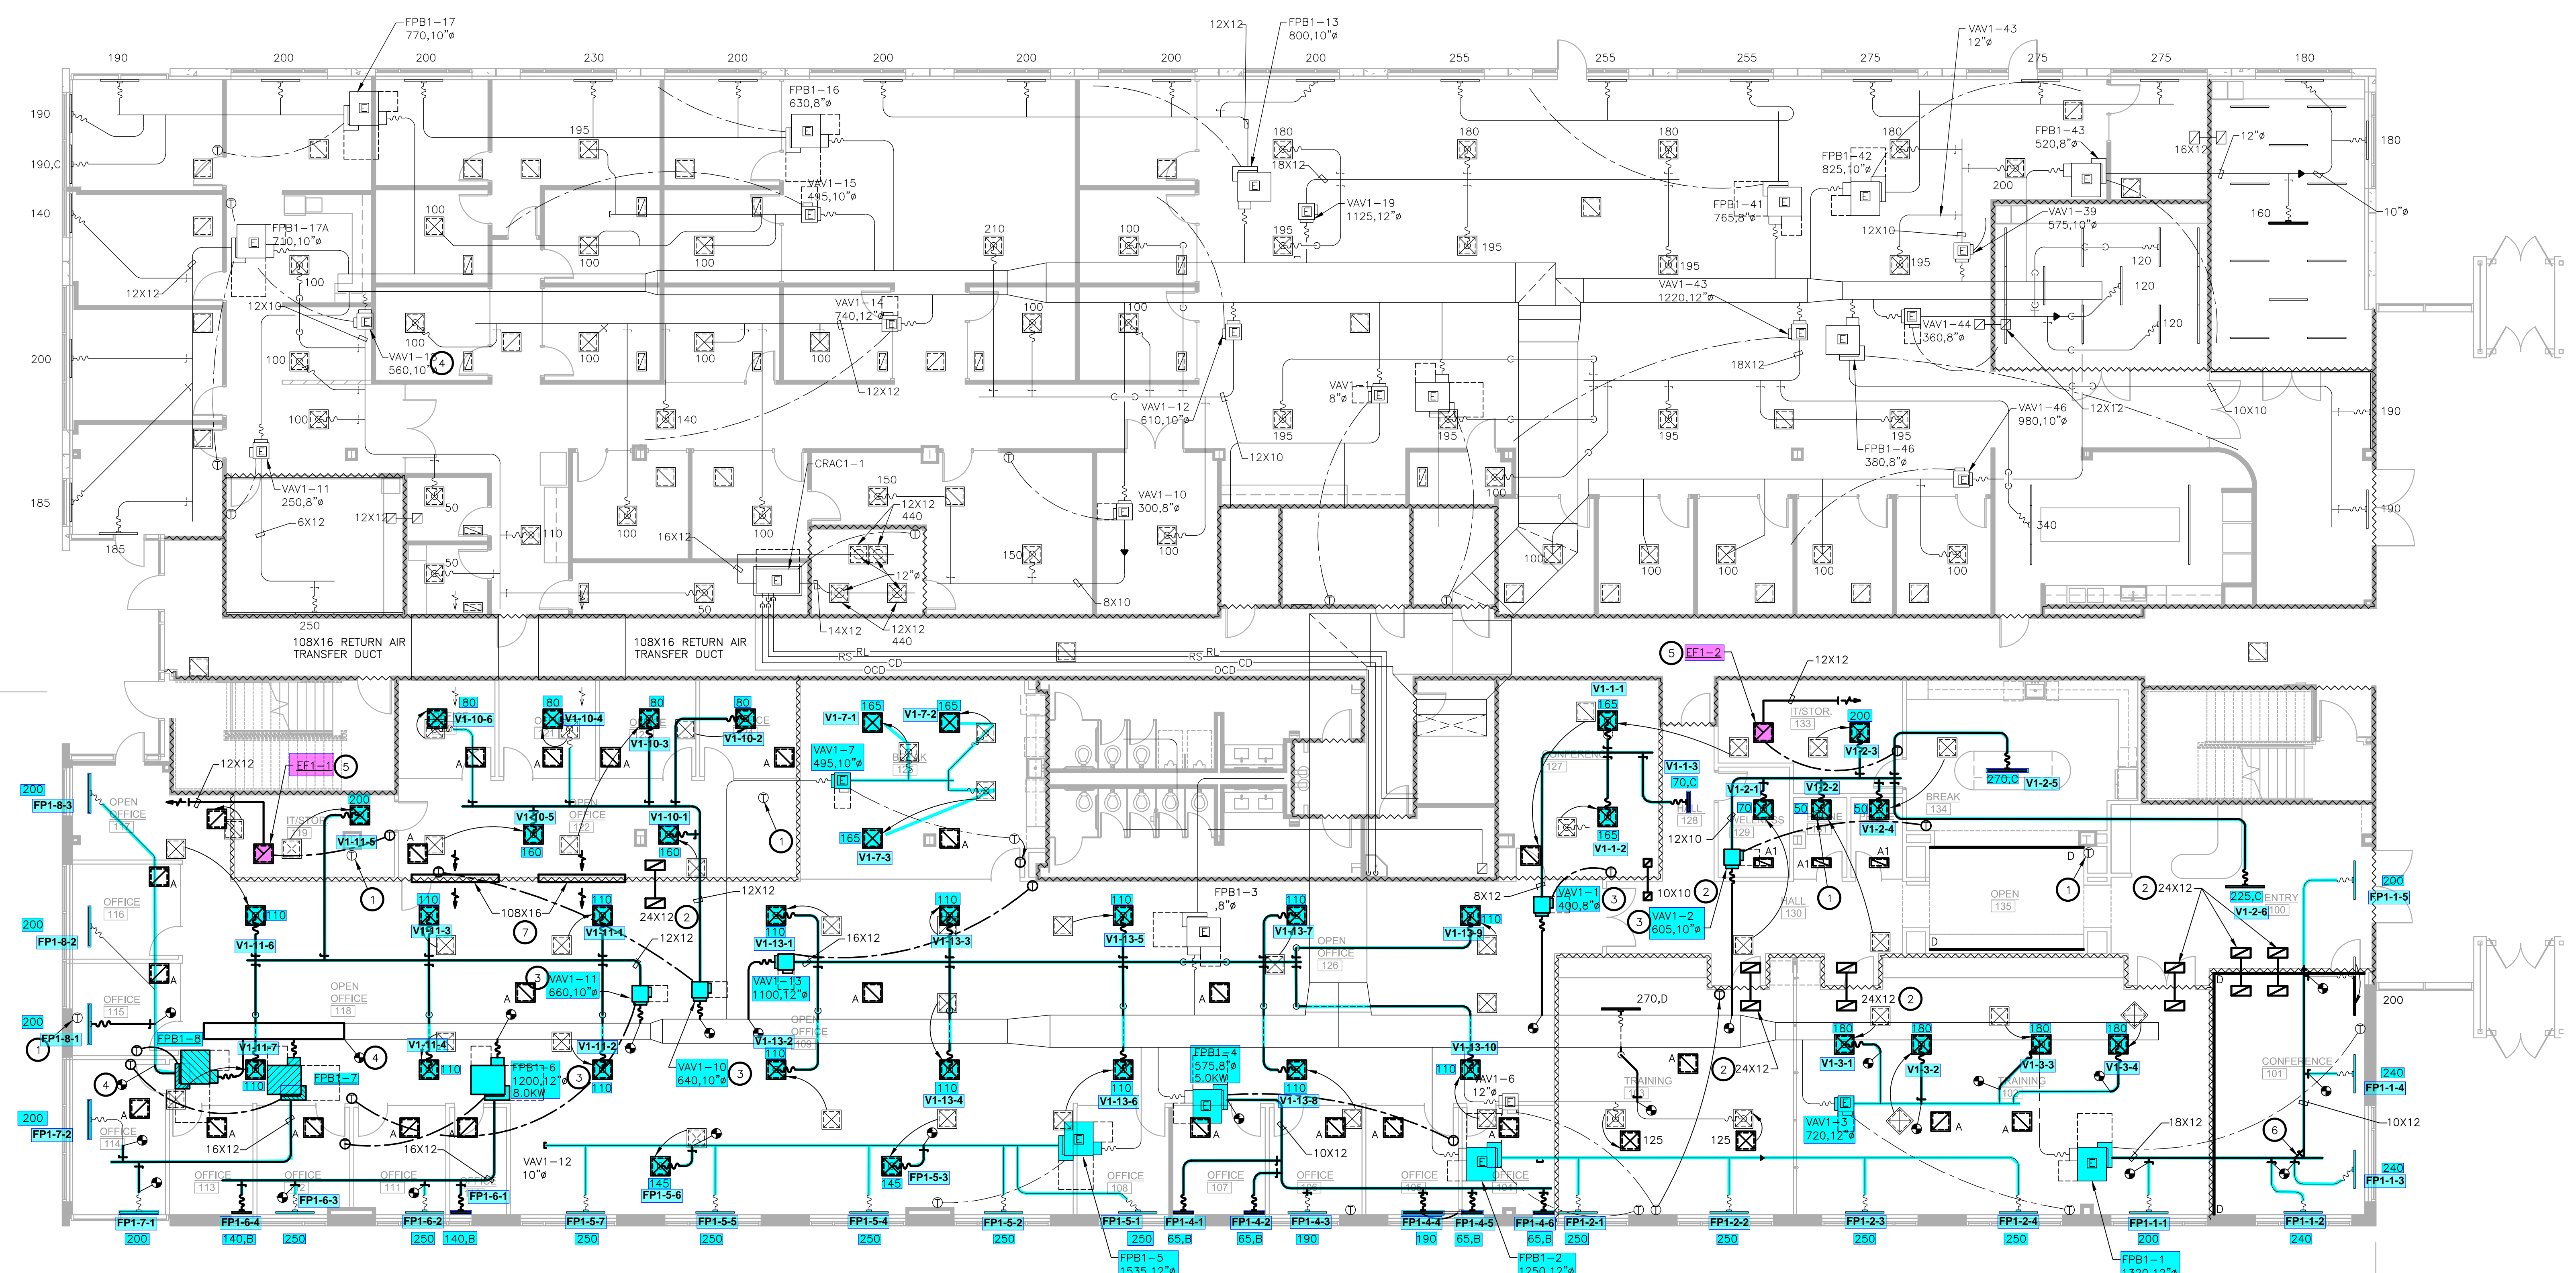

SUITE 1500
AVAILABLE

1 LEVEL 01 MECHANICAL PLAN
SCALE: 1/8"=1'-0"

