

SHEET ISSUE:


NO.	DATE	DESCRIPTION	BY
A	12/11/2024	CONSTRUCTION DOCUMENTS	MPS
D	02/20/2025	SCO CD REVIEW	MPS
E	03/10/2025	BID SET (SCO REVIEW)	MPS

PRINCIPAL IN CHARGE: RVA
 PROJECT ARCHITECT: MVO
 DRAWN BY: Author


SHEET TITLE:
**LEVEL 1 OVERALL
 PLAN - MECHANICAL
 PIPING**

SHEET NO. PROJ. NO.
 023145.00

M210

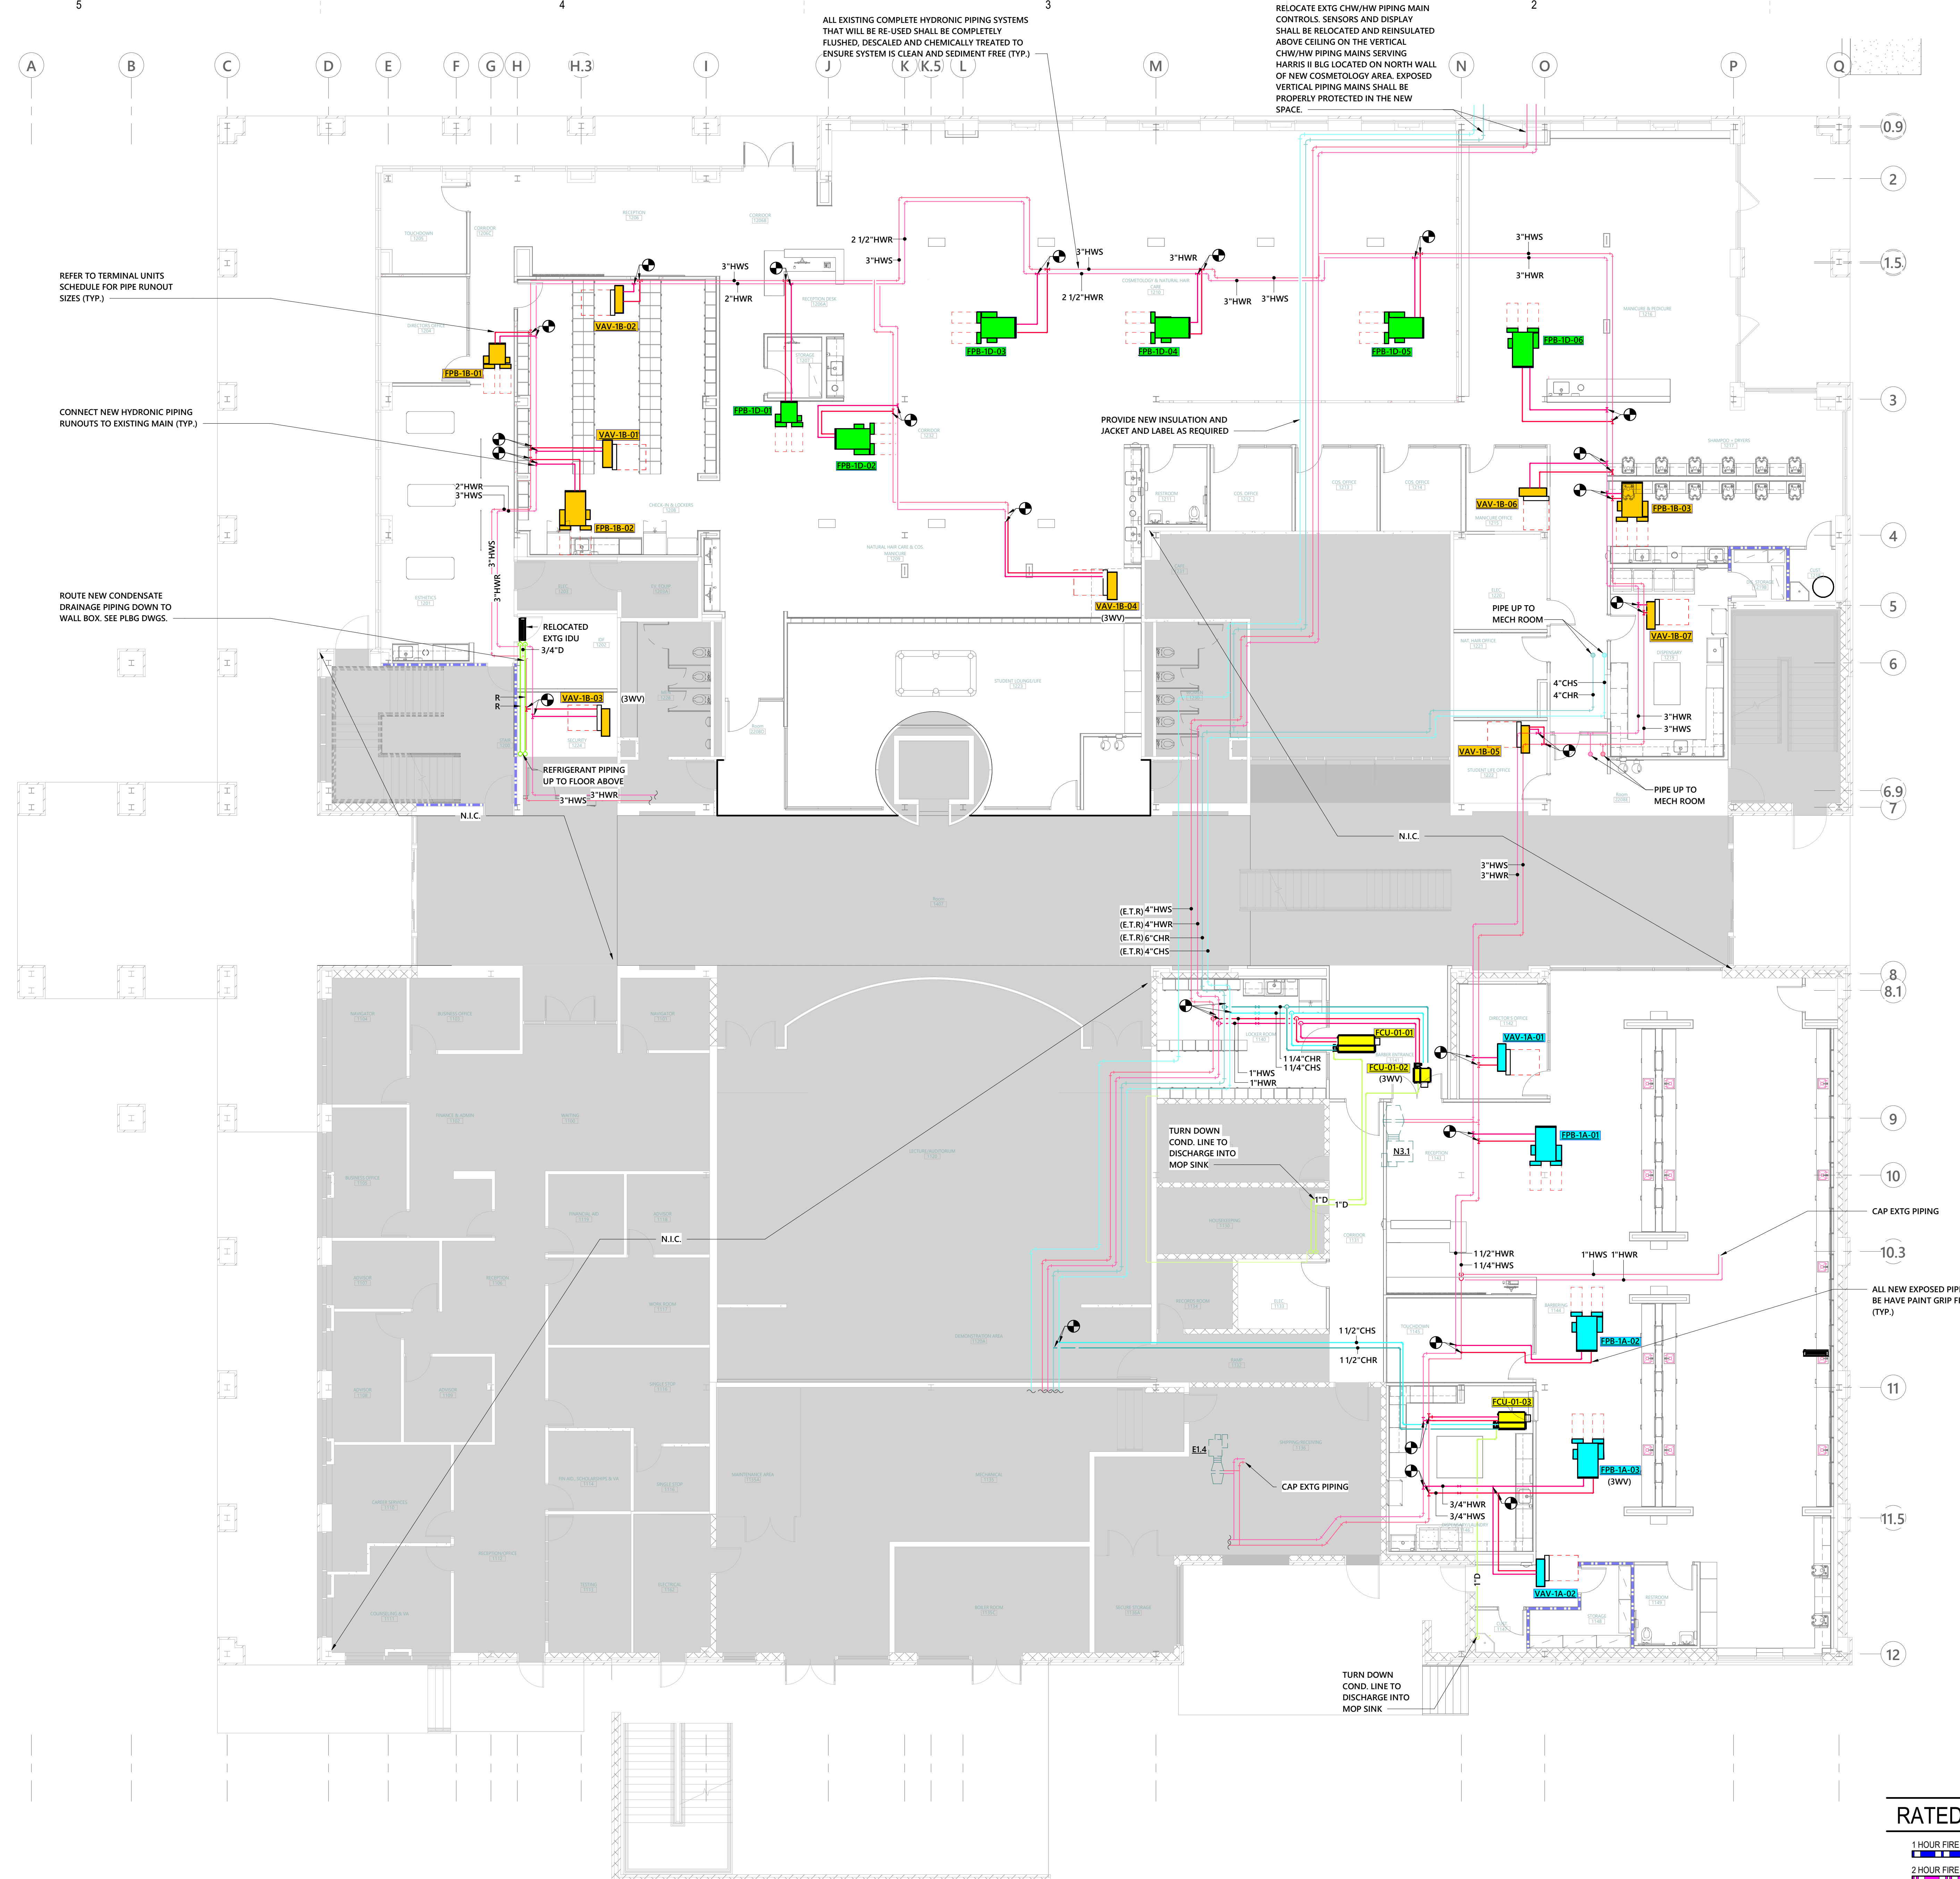

1 LEVEL 01 - FLOOR PLAN - MECHANICAL PIPING
 1/8" = 1'-0"

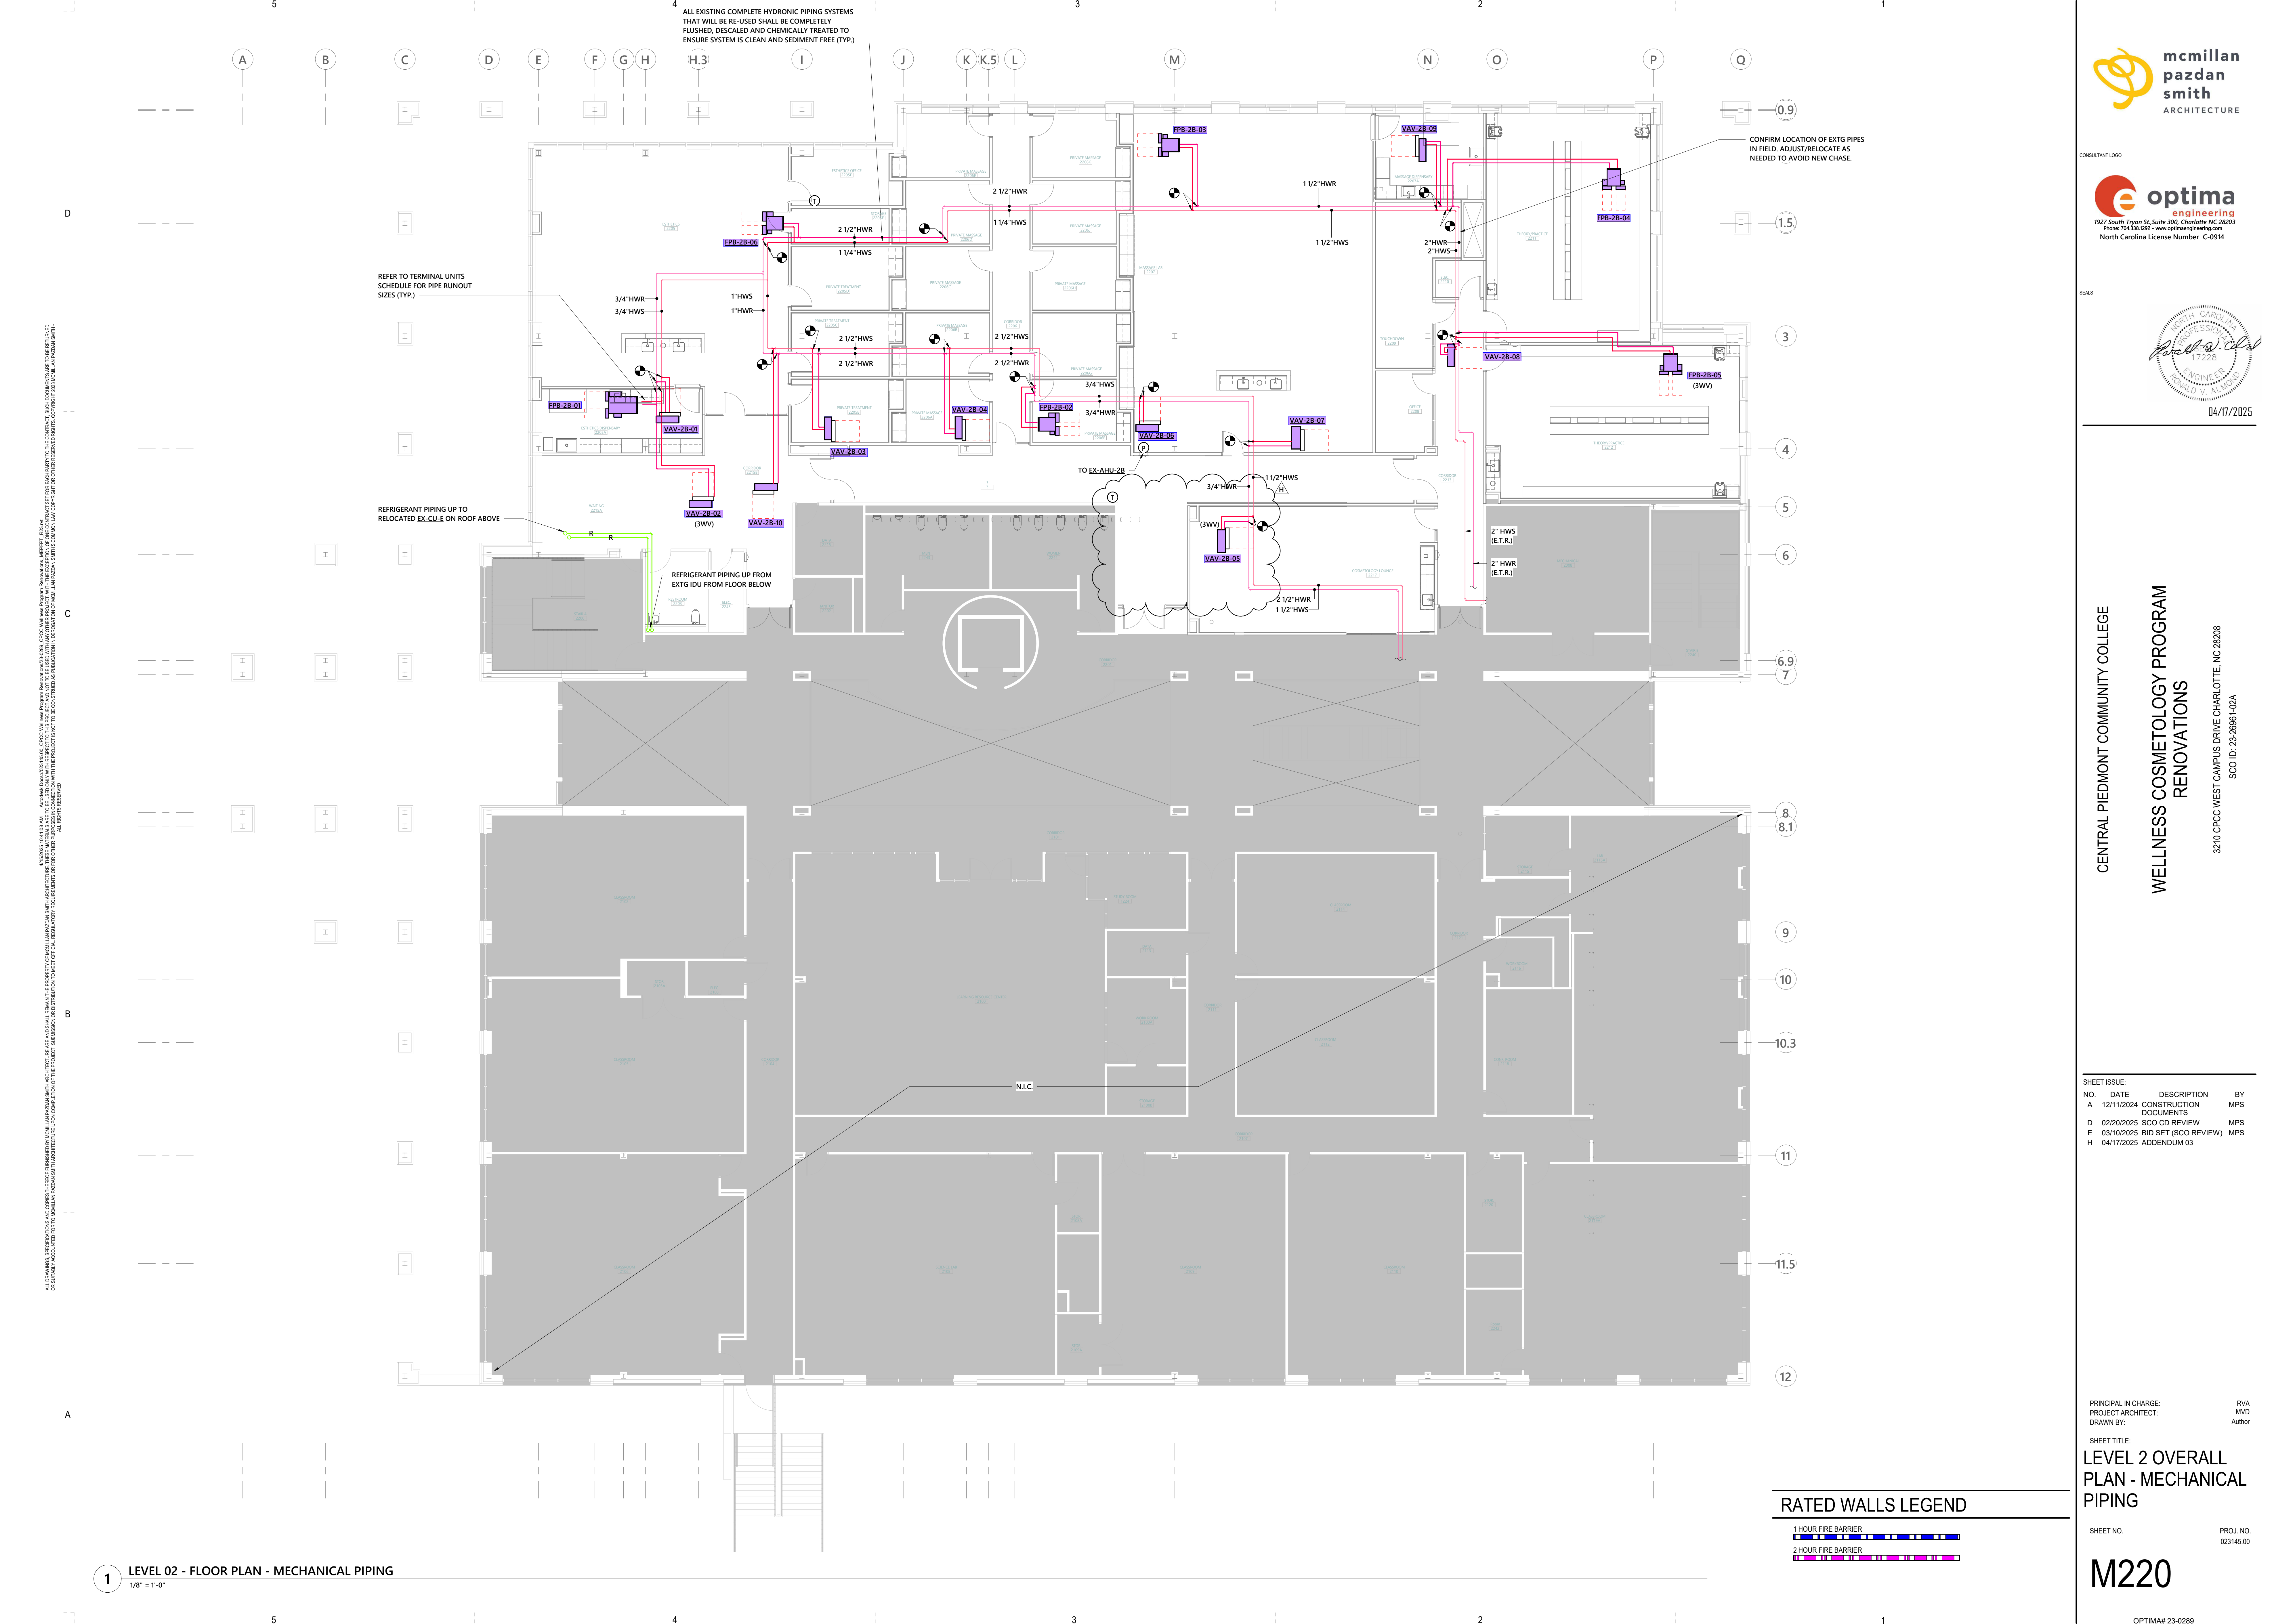

ALL EXISTING COMPLETE HYDRONIC PIPING SYSTEMS THAT WILL BE RE-USED SHALL BE COMPLETELY FLUSHED, DESCALED AND CHEMICALLY TREATED TO ENSURE SYSTEM IS CLEAN AND SEDIMENT FREE (TYP.)


REFER TO TERMINAL UNITS SCHEDULE FOR PIPE RUNOUT SIZES (TYP.)

REFRIGERANT PIPING UP TO RELOCATED EX-CLE ON ROOF ABOVE

REFRIGERANT PIPING UP FROM EXTG IDU FROM FLOOR BELOW

CONFIRM LOCATION OF EXTG PIPES IN FIELD. ADJUST/RELOCATE AS NEEDED TO AVOID NEW CHASE.

ALL DRAWINGS, SPECIFICATIONS AND COPIES THEREOF FURNISHED BY MCMILLAN PAZDAN SMITH ARCHITECTURE ARE AND SHALL REMAIN THE PROPERTY OF MCMILLAN PAZDAN SMITH ARCHITECTURE. THESE DRAWINGS ARE TO BE USED ONLY WITH RESPECT TO THE PROJECT AND MAY NOT BE REPRODUCED OR TRANSMITTED IN ANY FORM OR BY ANY MEANS, ELECTRONIC OR MECHANICAL, INCLUDING PHOTOCOPYING, RECORDING, OR BY ANY INFORMATION STORAGE AND RETRIEVAL SYSTEM, WITHOUT THE WRITTEN PERMISSION OF MCMILLAN PAZDAN SMITH ARCHITECTURE. ANY UNAUTHORIZED REPRODUCTION OR TRANSMISSION OF THESE DRAWINGS IS STRICTLY PROHIBITED. MCMILLAN PAZDAN SMITH ARCHITECTURE ASSUMES NO LIABILITY FOR ANY ERRORS OR OMISSIONS IN THESE DRAWINGS. THE USER ASSUMES ALL LIABILITY FOR ANY SUCH ERRORS OR OMISSIONS. COPYRIGHT © 2025 MCMILLAN PAZDAN SMITH ARCHITECTURE. ALL RIGHTS RESERVED.

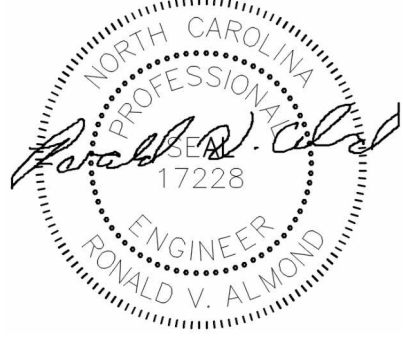

04/17/2025

CENTRAL PIEDMONT COMMUNITY COLLEGE
 WELLNESS COSMETOLOGY PROGRAM
 RENOVATIONS
 3210 CPCC WEST CAMPUS DRIVE CHARLOTTE, NC 28208
 SCO ID: 23-28861-02A

SHEET ISSUE:

NO.	DATE	DESCRIPTION	BY
A	12/11/2024	CONSTRUCTION DOCUMENTS	MPS
D	02/20/2025	SCO CD REVIEW	MPS
E	03/10/2025	BID SET (SCO REVIEW)	MPS
H	04/17/2025	ADDENDUM 03	


PRINCIPAL IN CHARGE: RVA
 PROJECT ARCHITECT: MVO
 DRAWN BY: Author

SHEET TITLE:
**LEVEL 2 OVERALL
 PLAN - MECHANICAL
 PIPING**

SHEET NO. PROJ. NO.
 023145.00

M220

RATED WALLS LEGEND

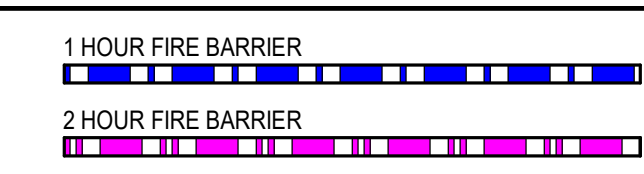

1 LEVEL 02 - FLOOR PLAN - MECHANICAL PIPING
 1/8" = 1'-0"