


COORDINATE WITH MECHANICAL CONTRACTOR FOR ALL OTHERS TO BE SHOWN.

- RECOMMENDED HANG STRUTS:
1. HANGING CO. COOLING 37"
 2. HANGING CO. COOLING 74"

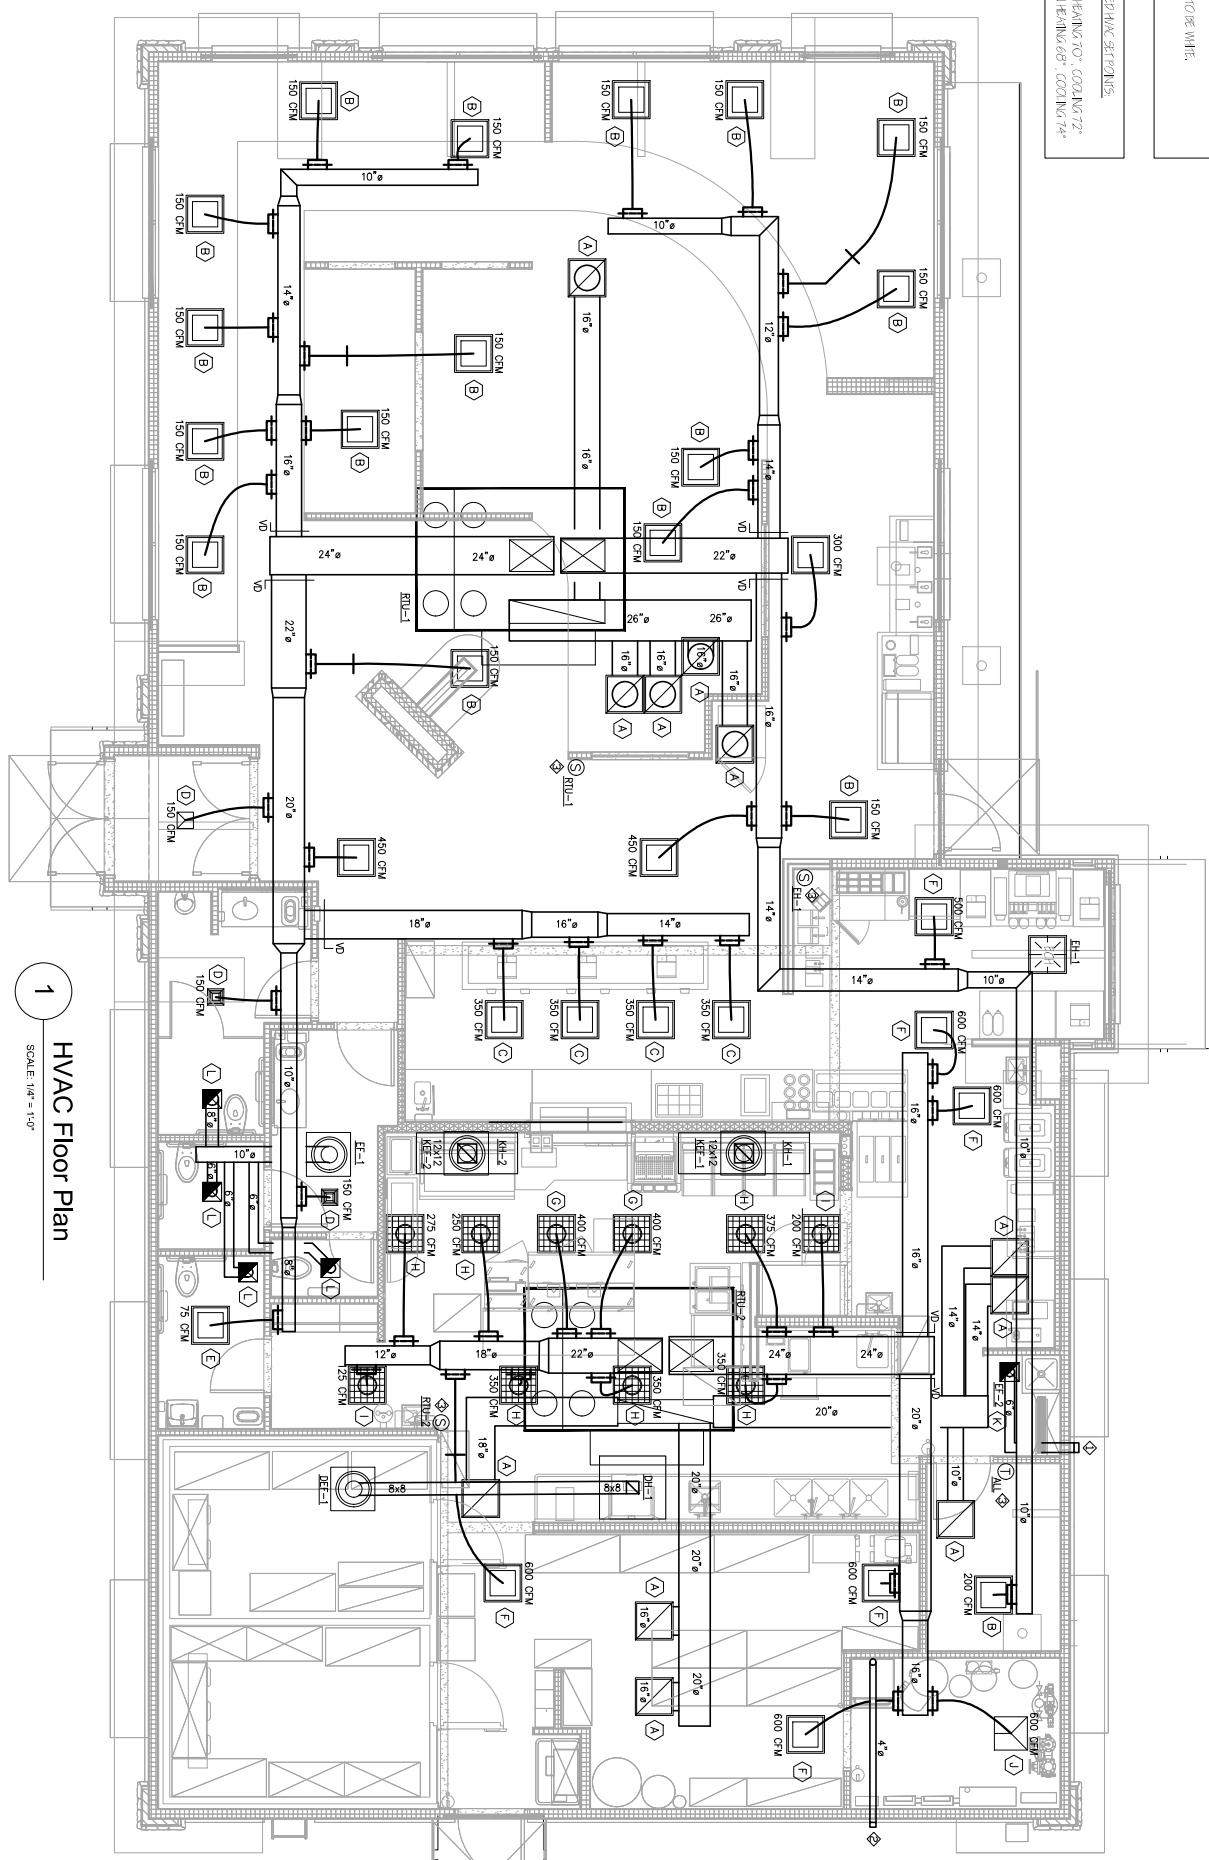

1 HVAC Floor Plan
SCALE: 1/4" = 1'-0"

WITH WALL CAP,
E WITH DRIVER
CONTROLLED BY

4 WAY
2 WAY
2 WAY