


COORDINATE WITH BUSSE-SPRINGER
FOR ALL NOTES TO BE WHITE.

- RECOMMENDED HANG STRUTS:
1. HANGING CO. COILING 77'
 2. HANGING CO. COILING 74'

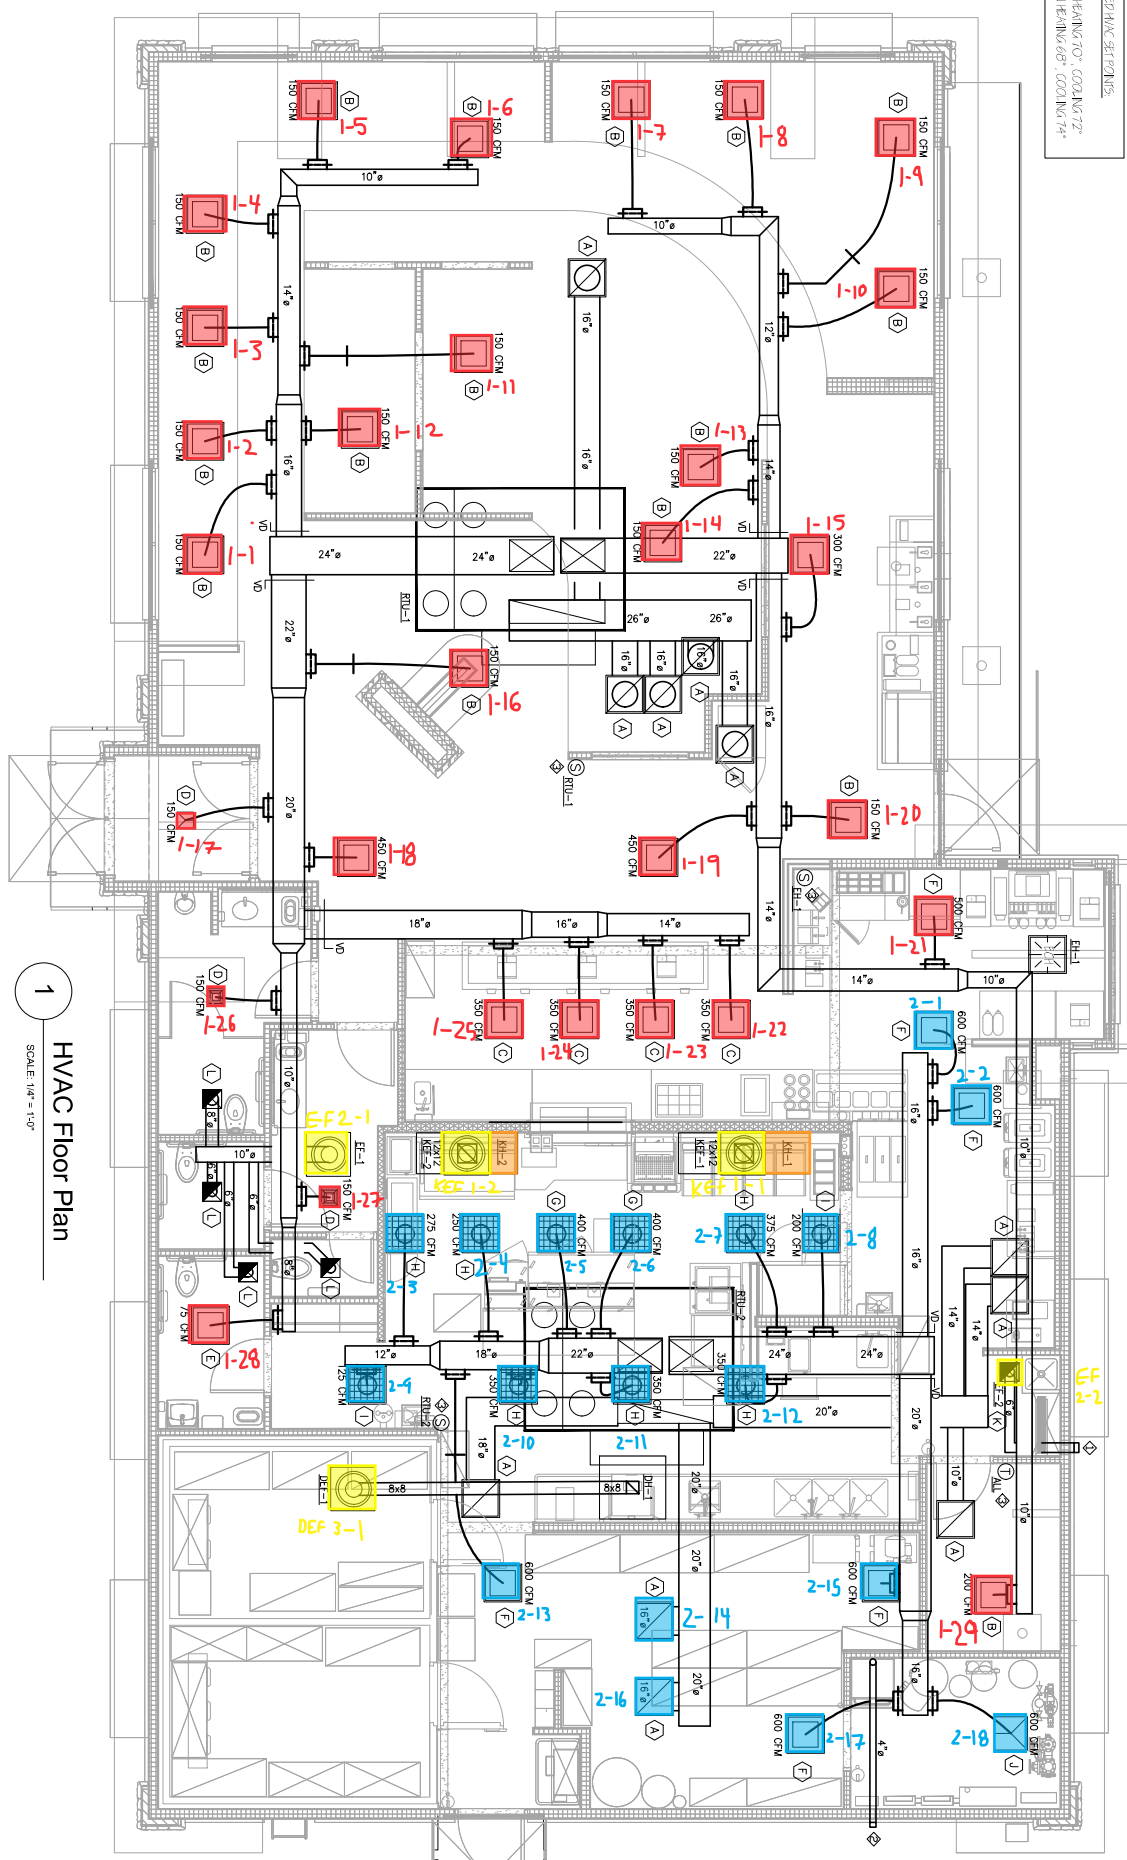

1
SCALE: 1/4" = 1'-0"
HVAC Floor Plan

WITH WALL CAP,
E WITH DRIVER
CONTROLLED BY

4 WY
2 WY
2 WY