



CODED NOTES:

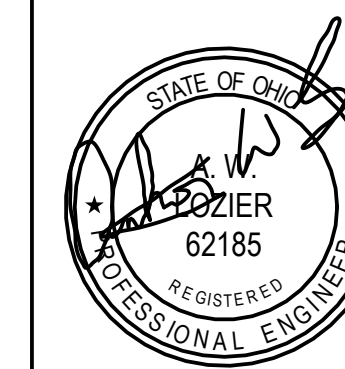

ISSUED	DATE
<input type="checkbox"/> BID/PERMIT	08/12/2025

SHEET TITLE	
2ND FLOOR HVAC PLAN	
SHEET SIZE	COMM No.
24" x 36"	E-12772
DRAWN BY	DATE
CBP	08/12/2025
SHEET #	
M121	

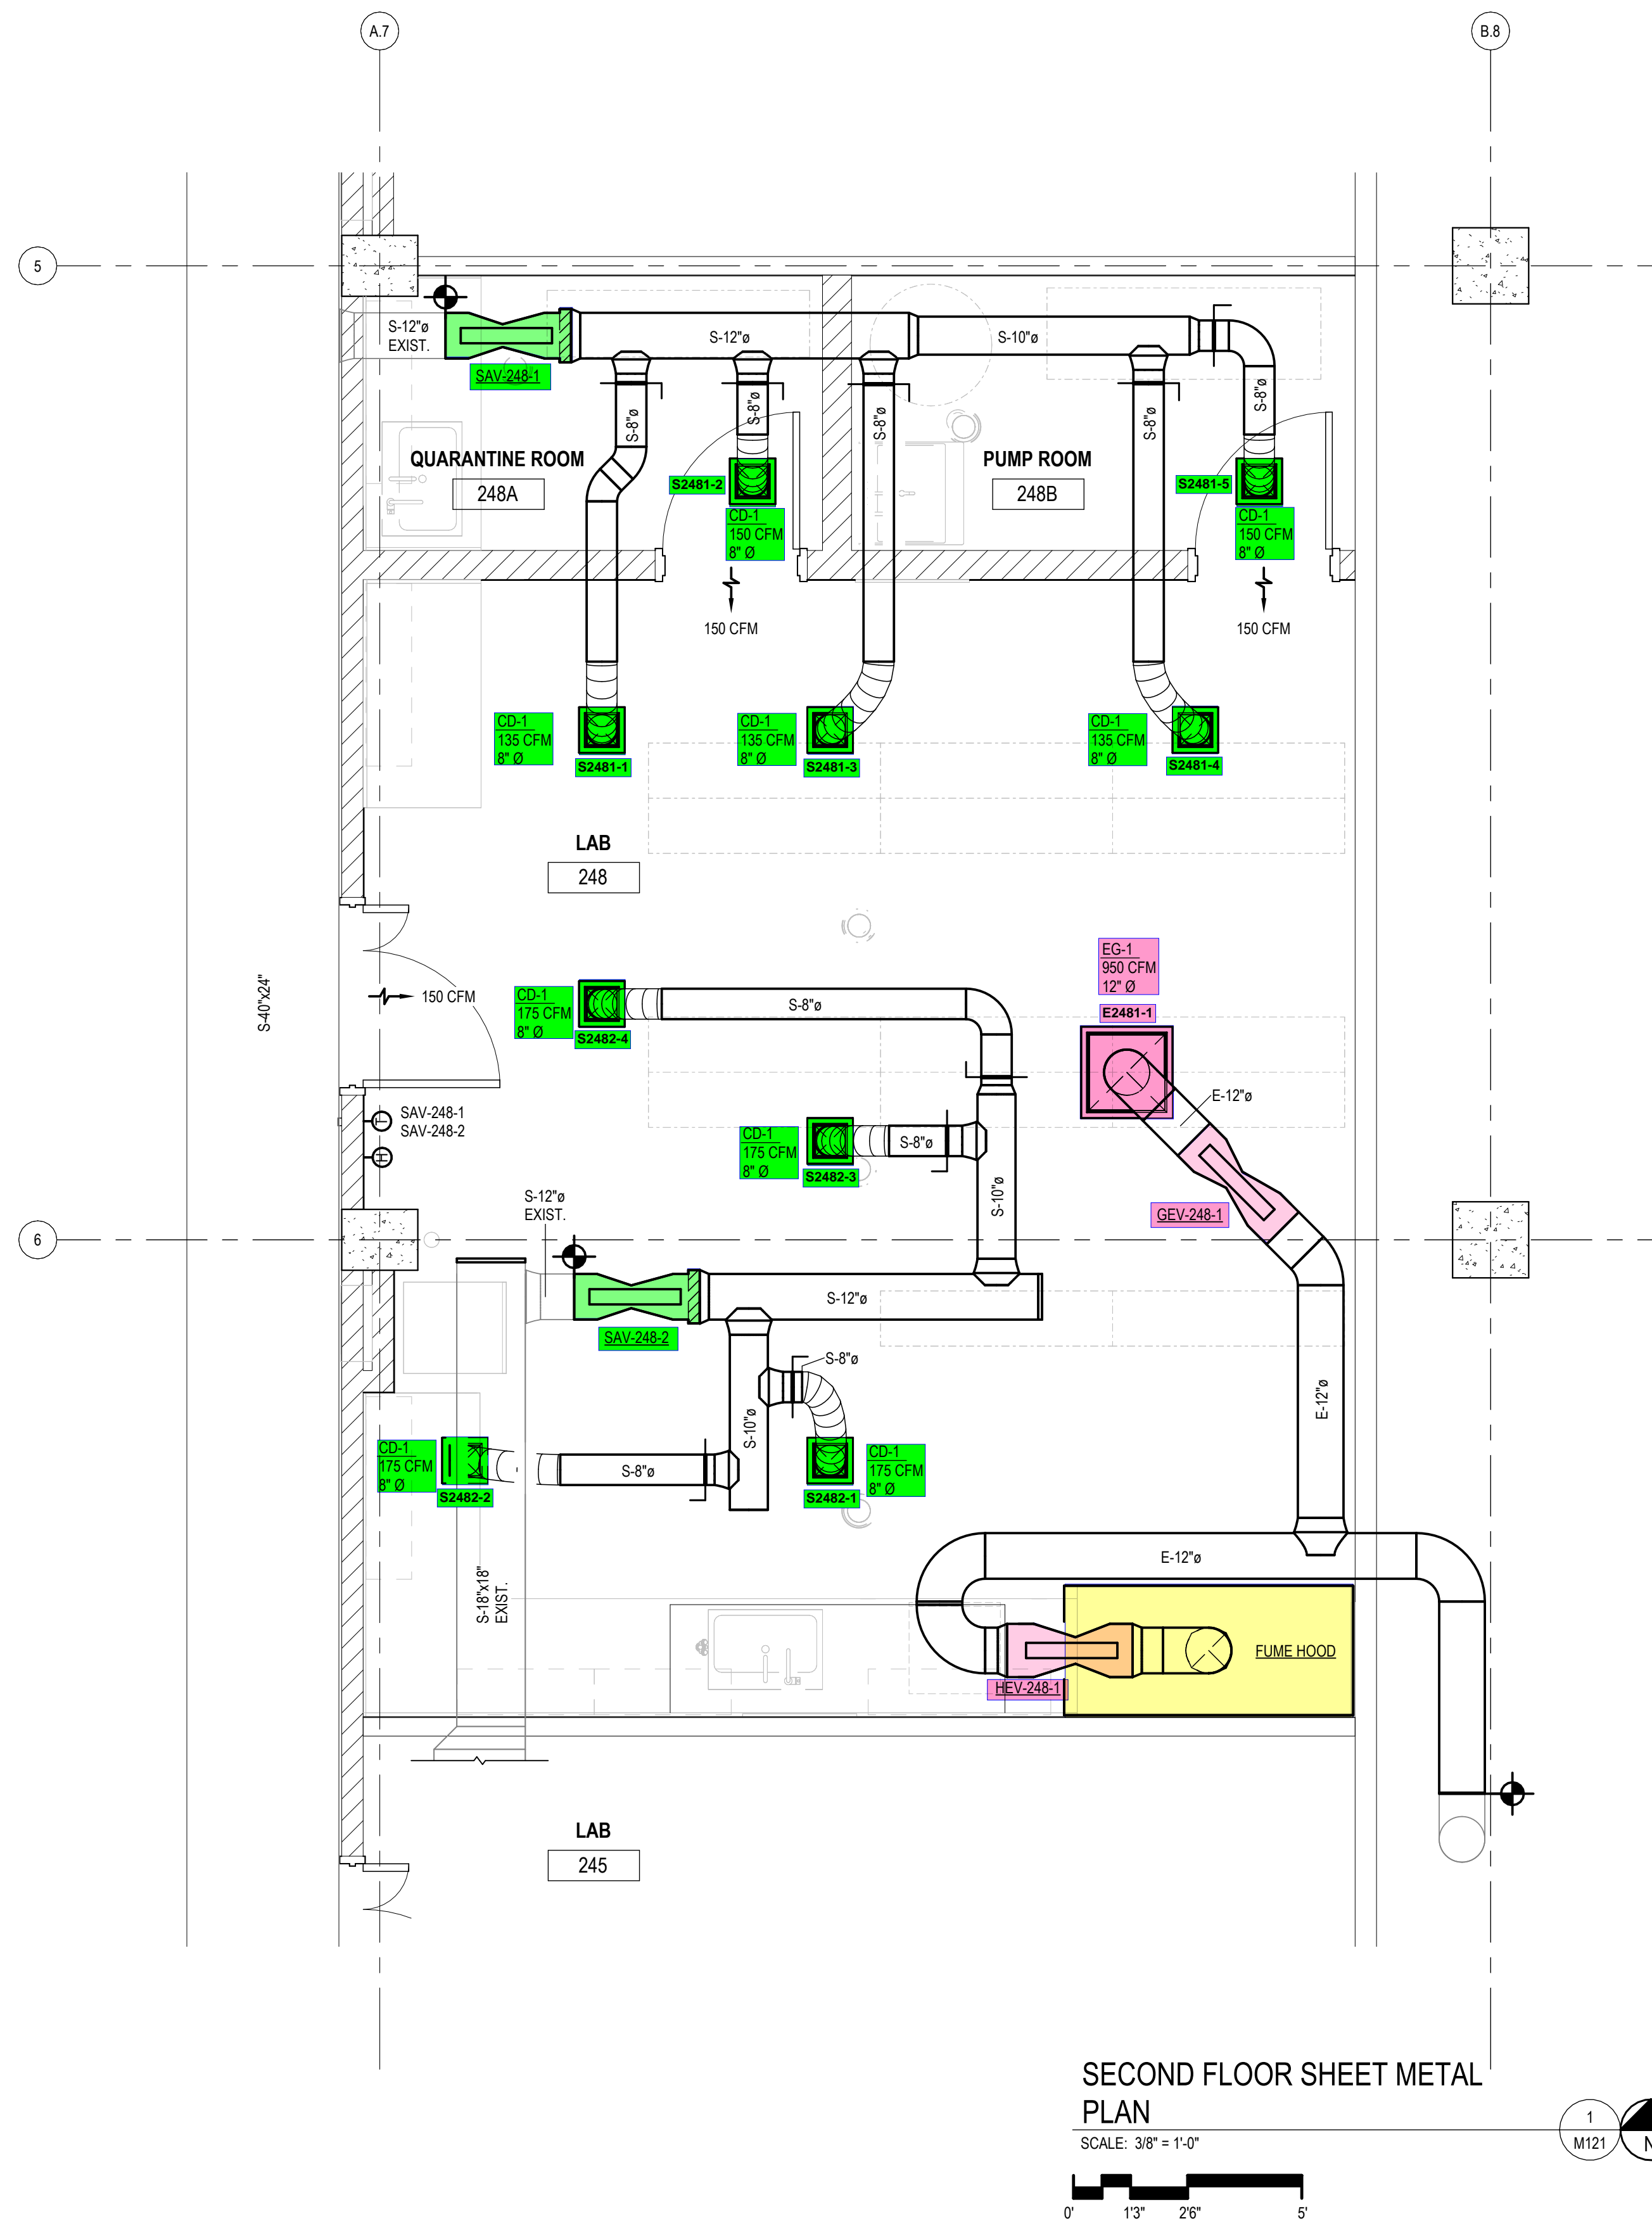

SECOND FLOOR SHEET METAL PLAN

SCALE: 3/8" = 1'-0"

