


**01 FLOOR PLAN - MECHANICAL**  
SCALE: 1/8"=1'-0"

**NOTES BY SYMBOL "O"**

1. CONTRACTOR TO MOVE VAV BOX PLAN NORTH OF NEW WALL AS SHOWN, ADJUST TAPS AS NECESSARY.
2. REMOVE AND RELOCATE DIFFUSER/REGISTER AS NECESSARY. ADJUST TO CFM SHOWN FOR SUPPLY DIFFUSER. IF NOT RELOCATED, REMOVE AND RETURN TO OWNER.
3. RELOCATED THERMOSTAT. CONTRACTOR TO VERIFY WITH OWNER ON EXACT LOCATION.
4. PLACE D-TYPE RETURN REGISTER IN PLACE OF SUPPLY DIFFUSER.
5. ADJUST DIFFUSER TO NEW CFM AS SHOWN.

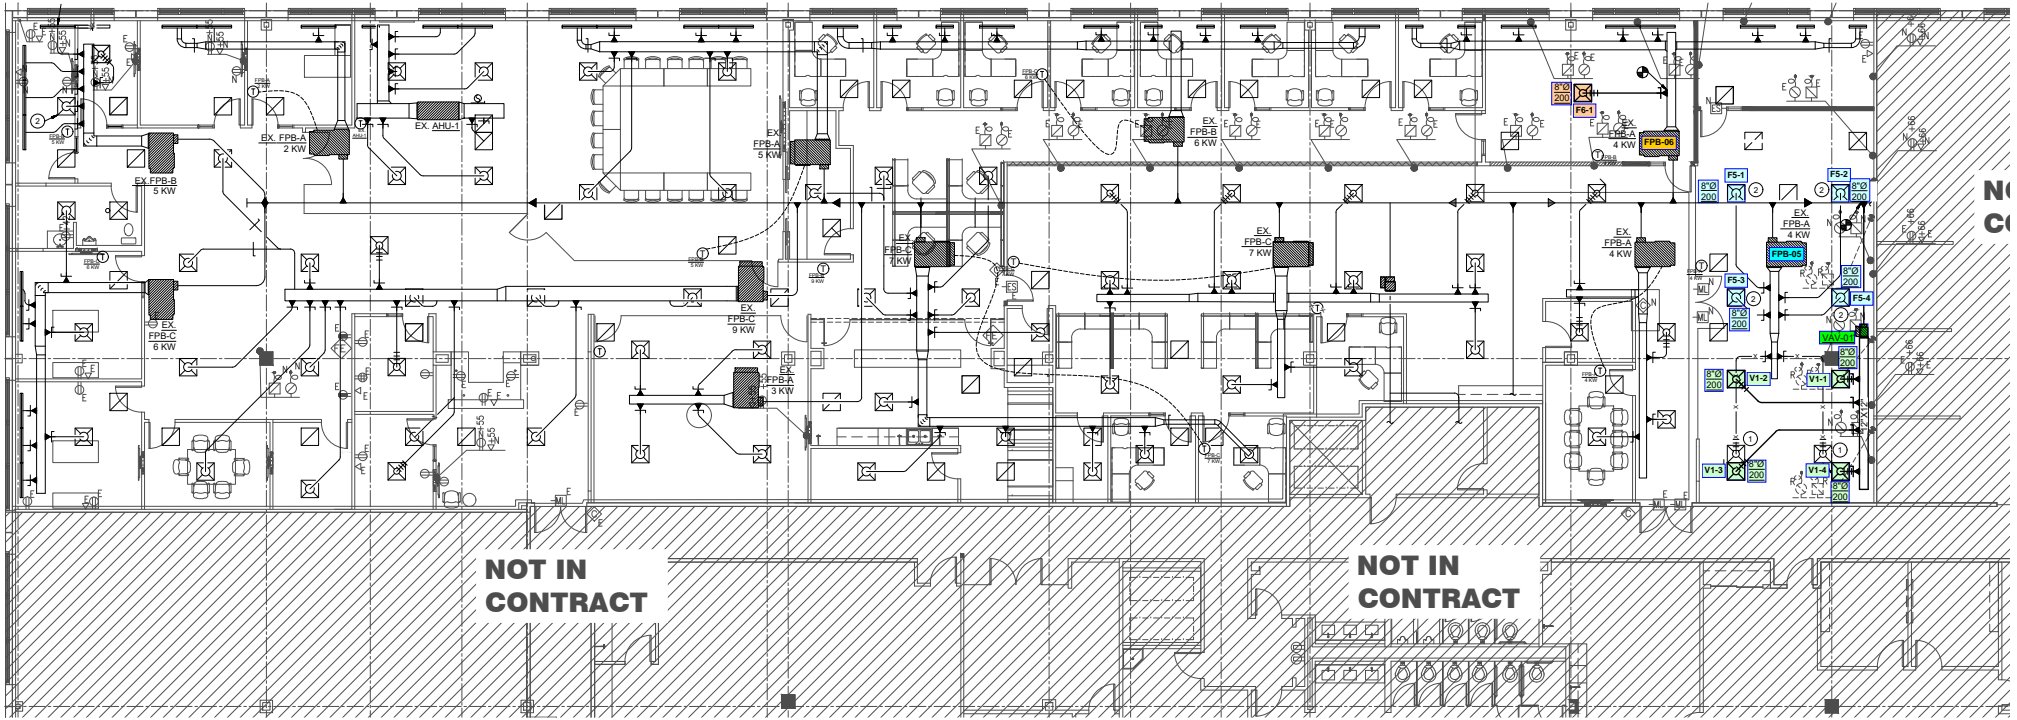

**01 FLOOR PLAN - DUCTWORK**  
 SCALE: 1/8"=1'-0"

**NOTES BY SYMBOL "○"**

1. DISCONNECT DIFFUSER FROM FPB-A AND TIE INTO VAV-01. RELOCATE DIFFUSER AS SHOWN.
2. RE-BALANCE DIFFUSER TO 200 CFM.